 
 
 
 
 
 
 
 
 


SYMBOL	DESCRIPTION
	12m Height , Octagonal Street Lighting Pole - Single Arm With 1X150w LED LAMP, Efficacy >140lm/w , IP66
	12m Height , Octagonal Street Lighting Pole - Double Arm With 2X150w LED LAMP, Efficacy >140lm/w, P66.
	TUNNEL LIGHTING FIXTURE, WALL MOUNTED WITH 1x150W LED LAMP, Efficacy >140lm/w , IP66 .
	UNDER BRIDGE RECESSED LIGHTING FIXTURE, WITH 1x150W LED LAMP, Efficacy >140lm/w, IP66 .
	RECESSED LIGHTING FIXTURE FOR BRIDGE WITH REFLECTR , 1x40W LED LAMP ,Efficacy >140lm/w, IP67 .
	PRESS TUNNEL DISTRIBUTION PANEL,IP65.
	ISOLATION PANEL FOR TUNNEL LIGHTING, IP65.
	TELECOMMUNICATION MANHOLE (60x60x60)cm.
	CONCRETE INSPECTION PIT (40X40)cm WITH SOLID COPPER ROD.
	EARTHING COPPER ROD 3.0m LENGTH, 20mm DIAMETER.
	ELECTRICAL POWER CABLE, IN 100 UPVC CONDUIT AT DEPTH 80cm.
	STREET LIGHTING POWER CABLE, IN 75 UPVC CONDUIT AT DEPTH 80cm.
	ELECTRICAL CONCRETE TRENCH ROAD CROSSING, (TYPE: ECT-2). WITH 2X100mm UPVC CONDUIT.
	EXISTING STREET LIGHTING, SINGLE ARM POLE .
	EXISTING STREET LIGHTING, DOUBLE ARM POLE.
	EXISTING POWER TRANSFORMER.

SYMBOL	DESCRIPTION
	3-PHASE MOLDED CASE CIRCUIT BREAKER
	1-PHASE MOLDED CASE CIRCUIT BREAKER
	KILO WATT HOUR METER
	CURRENT TRANSFORMER
	THREE WAY SELECTOR SWITCH
	ASTRONOMICAL TIMER
	CONTACTOR
	INDICATOR LAMP
	LIGHTING FIXTURE WITH 1X18WATT FLUORESCENT LAMP MOUNTED INSIDE PANEL
	LIMIT SWITCH
	13A, SINGLE PHASE SOCKET OUTLET MOUNTED INSIDE PANEL

NOTES:-

Purpose Of Issue	Rev.	Date	Approved

Client:



GREATER AMMAN MUNICIPALITY

Project:

STRUCTURAL DESIGN SERVICES FOR
AMMAN BRT

Package:

PRESS TUNNEL

Title:

ELECTRICAL LEGEND


Consultant:



Design: S.H	Drawn by: CAD	Checked: KH.A
Scale: N.T.S.	Date: NOV. 2016	Approved: W.Z.



Drawing Number: E-000	Rev.: 0
--------------------------	------------

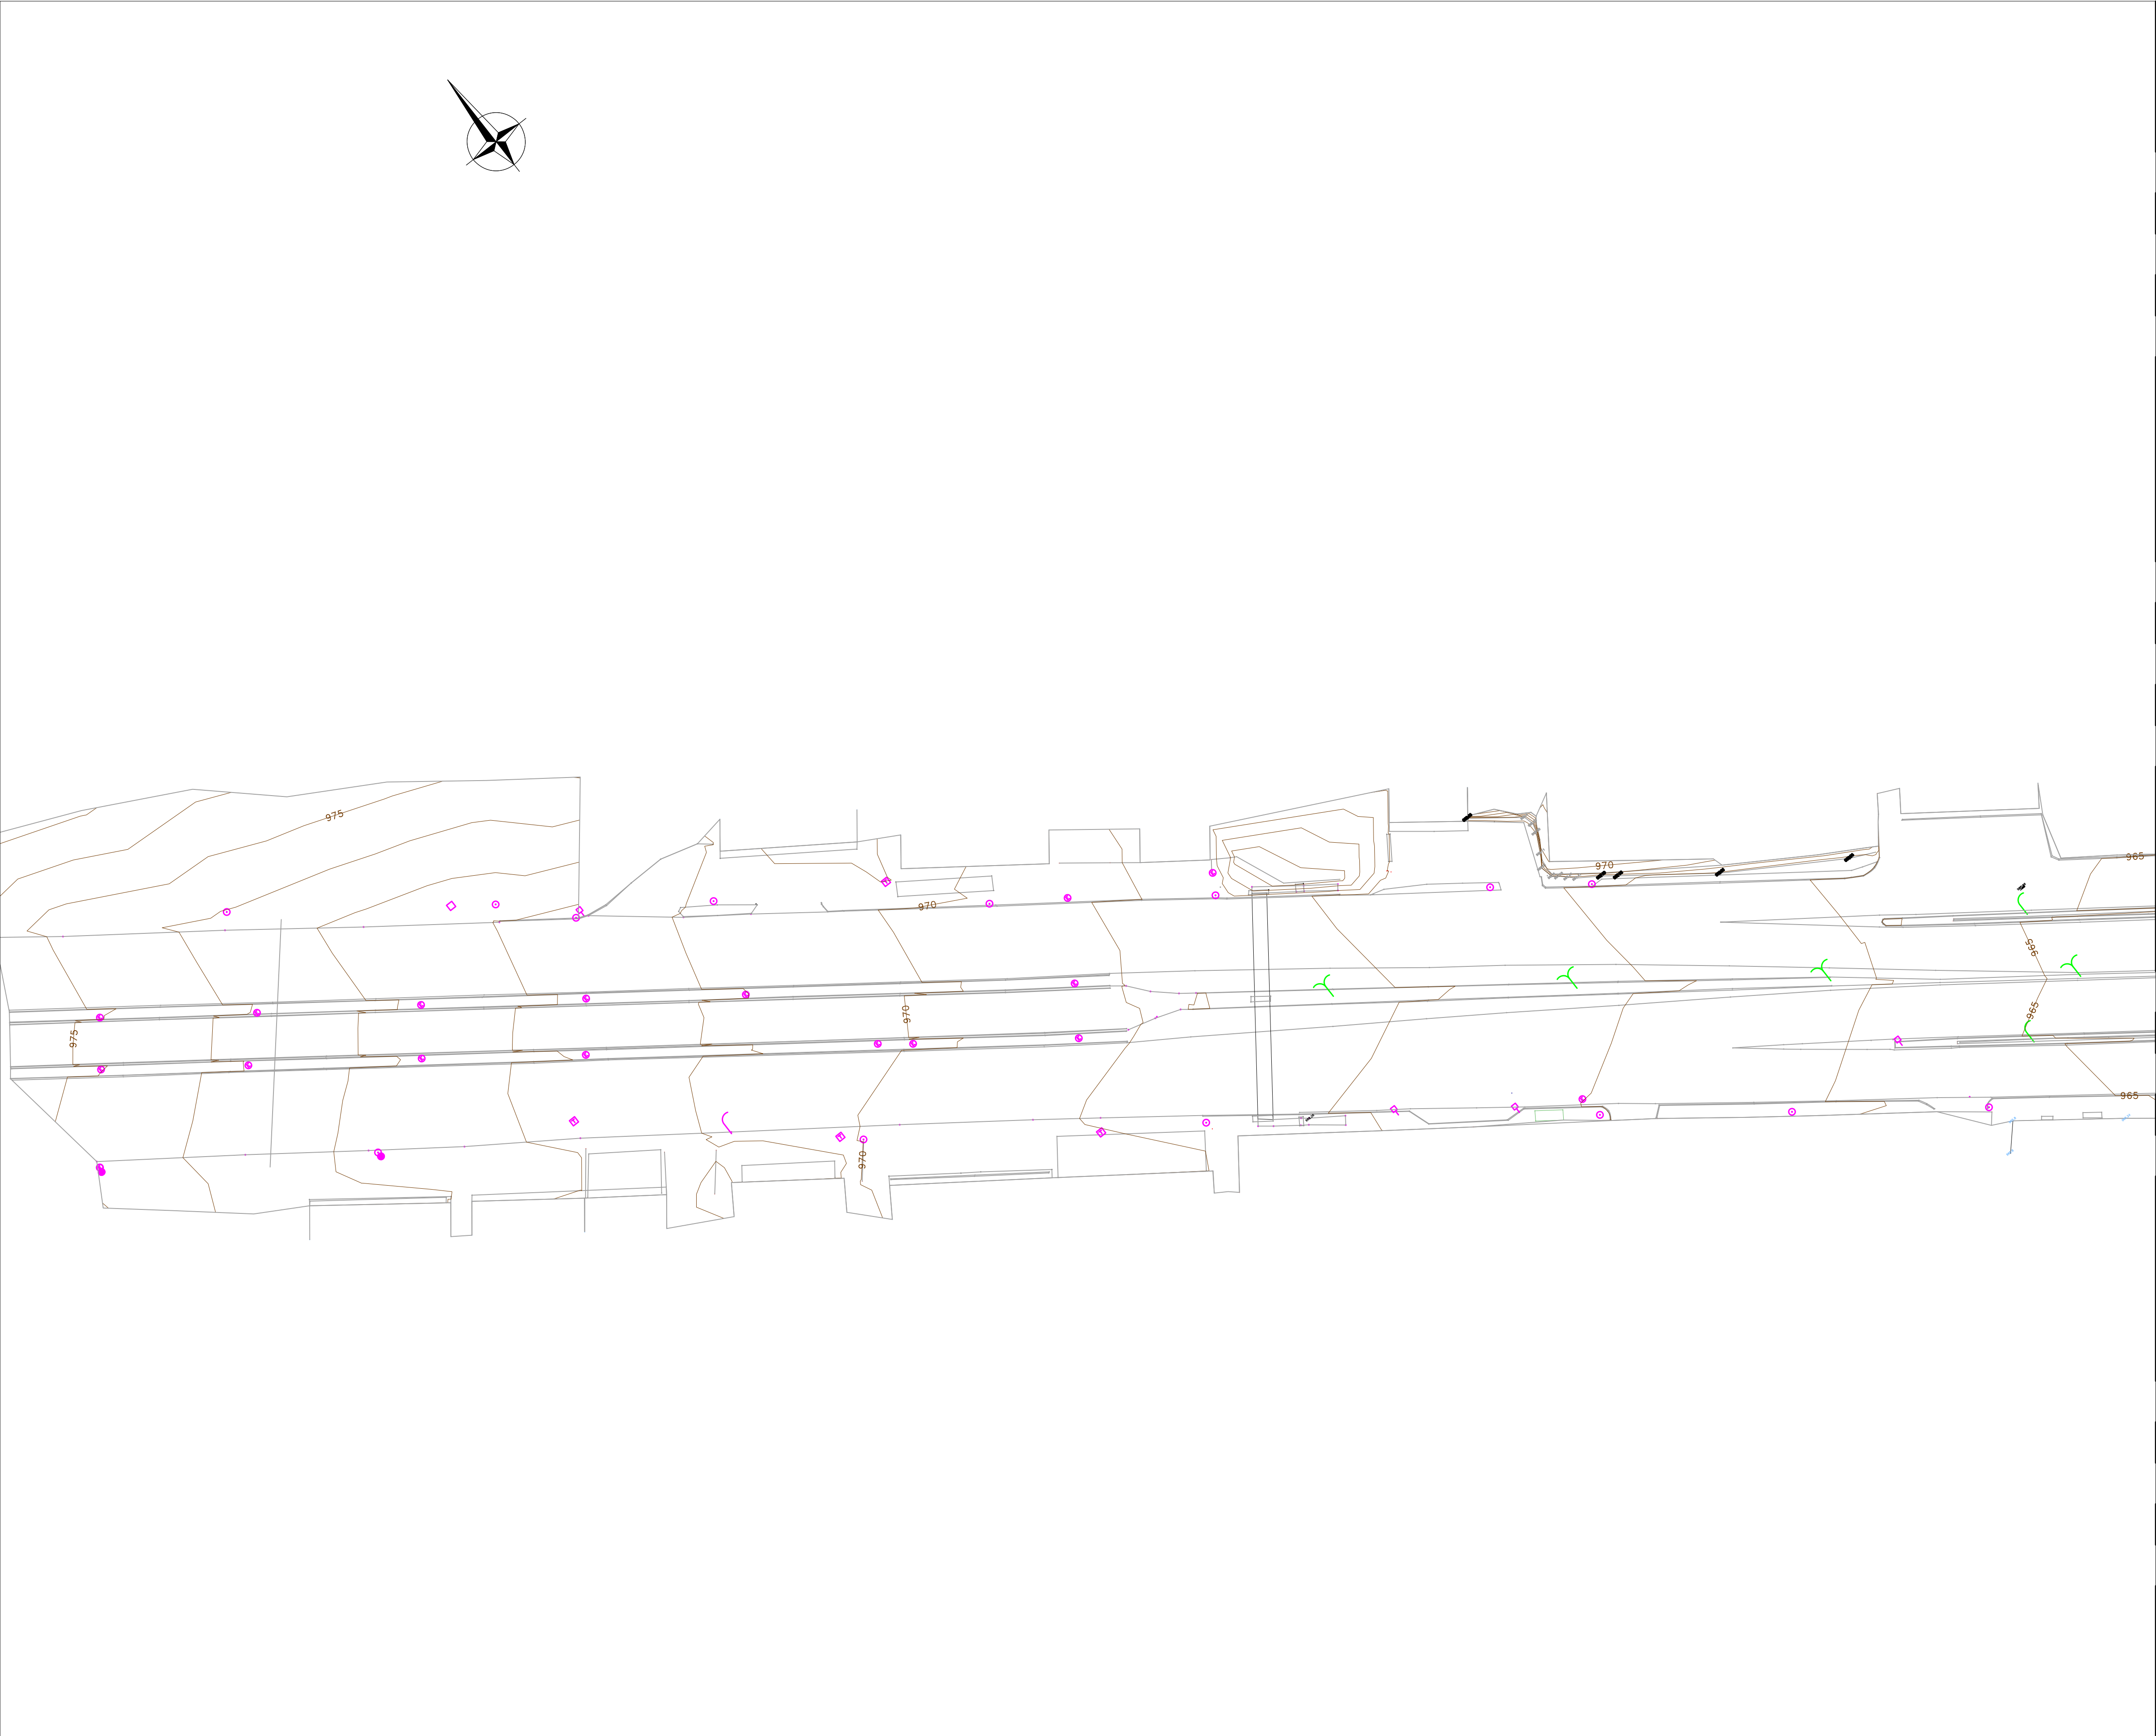

NOTES
LEGEND

EXISTING ELECTRICAL ITEMS TO BE DISMANTLED AND REMOVED IN COORDINATION WITH THE CONCERNED AUTHORITIES	
SYMBOL	DISCRIPTION
	STREET LIGHTING, SINGLE ARM POLE .
	STREET LIGHTING, DOUBLE ARM POLE.
	ELECTRIC POLE
	ELEC. MANHOLE
	TELEPHONE POLE
	TELEPHONE BOX

EXISTING ELECTRICAL ITEMS (NO ACTION).	
SYMBOL	DISCRIPTION
	ELECTRICAL TRANSFORMER.
	STREET LIGHTING, SINGLE ARM POLE .
	STREET LIGHTING, DOUBLE ARM POLE.
	ELECTRIC POLE
	ELEC. MANHOLE
	TELEPHONE POLE
	TELEPHONE BOX

Purpose Of Issue	Rev.	Date	Approved
------------------	------	------	----------

Client:



أمانة
عمّان
الكبرى

Project:

STRUCTURAL DESIGN SERVICES FOR
AMMAN BRT

Package:

PRESS TUNNEL

Title:

EXISTING LAYOUT
SHEET 1 OF 3

Consultant:





Design:	Drawn by:	Checked:
S.H	CAD	KH.A
Scale:	Date:	Approved:
1:5000	NOV. 2016	W.Z.



Drawing Number:	Rev.:
E-101	0

MATCH LINE SEE DWG. No. E-102

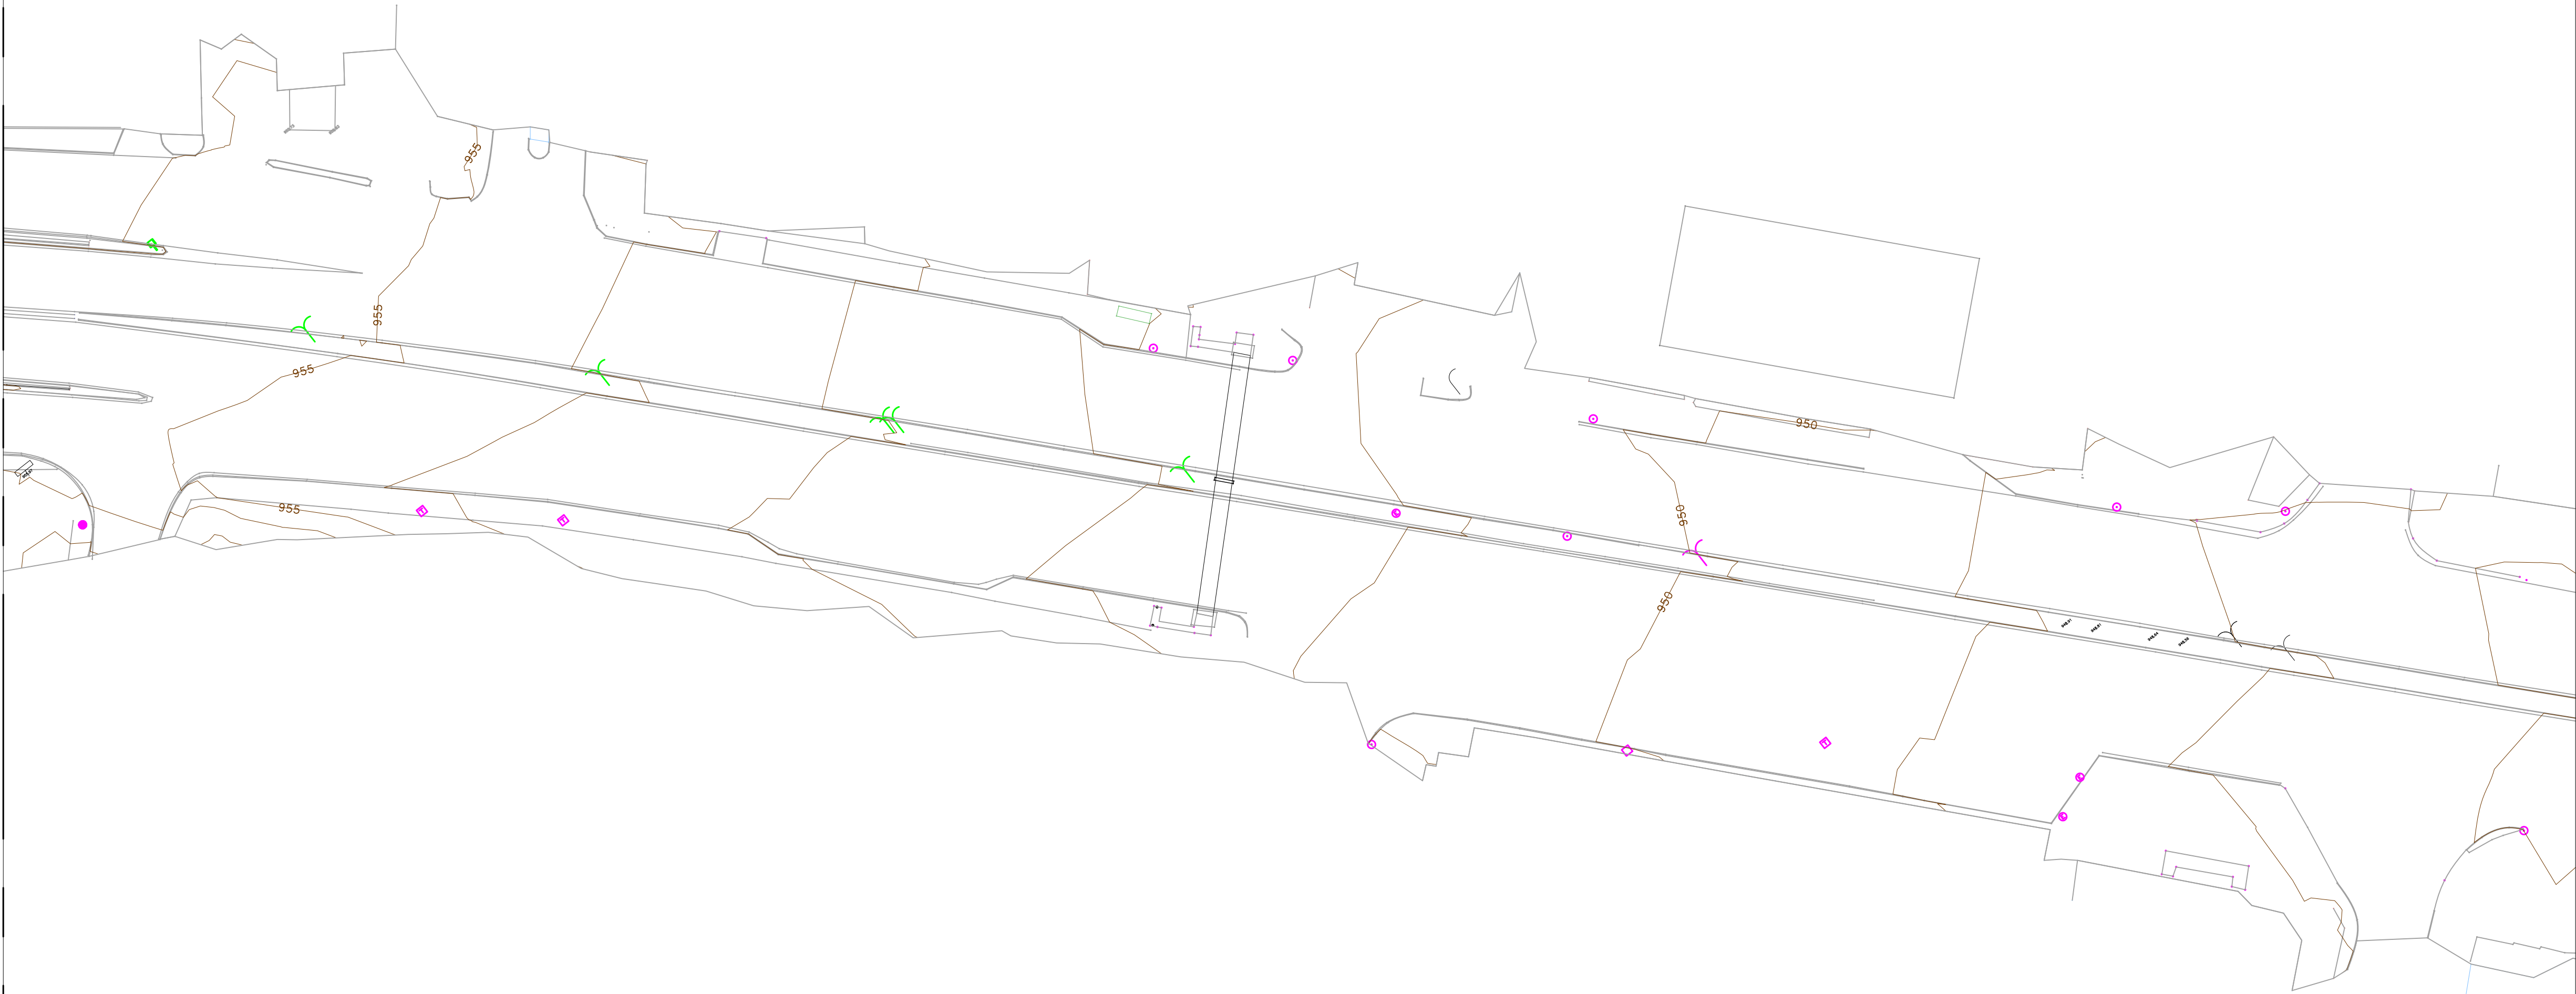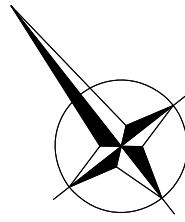

NOTES

LEGEND

EXISTING ELECTRICAL ITEMS TO BE DISMANTLED AND REMOVED IN COORDINATION WITH THE CONCERNED AUTHORITIES	
SYMBOL	DISCRIPTION
	STREET LIGHTING, SINGLE ARM POLE.
	STREET LIGHTING, DOUBLE ARM POLE.
	ELECTRIC POLE
	ELEC. MANHOLE
	TELEPHONE POLE
	TELEPHONE BOX

EXISTING ELECTRICAL ITEMS (NO ACTION).	
SYMBOL	DISCRIPTION
	ELECTRICAL TRANSFORMER.
	STREET LIGHTING, SINGLE ARM POLE.
	STREET LIGHTING, DOUBLE ARM POLE.
	ELECTRIC POLE
	ELEC. MANHOLE
	TELEPHONE POLE
	TELEPHONE BOX

Purpose Of Issue	Rev.	Date	Approved
------------------	------	------	----------

Client:



GREATER AMMAN MUNICIPALITY

Project:

STRUCTURAL DESIGN SERVICES FOR
AMMAN BRT

Package:

PRESS TUNNEL


Title:

EXISTING LAYOUT
SHEET 3 OF 3

Consultant:




Design:	Drawn by:	Checked:
S.H	CAD	KH.A
Scale:	Date:	Approved:
1:5000	NOV. 2016	W.Z.

 

Drawing Number:	Rev.:
E-103	0

NOTES:-

KEY MAP:-

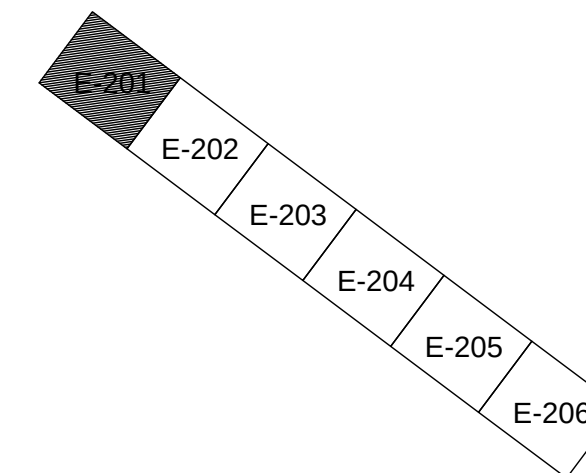

Purpose Of Issue	Rev.	Date	Approved

5	Client:
---	---------



GREATER AMMAN MUNICIPALITY

Project:

STRUCTURAL DESIGN SERVICES FOR
AMMAN BRT

Package:

PRESS TUNNEL


Title:

BRIDGE AND TUNNEL
LIGHTING SYSTEM LAYOUT
SHEET (1 OF 6)

Consultant:



Design: S.H	Drawn by: CAD	Checked: KH.A
Scale: 1:200	Date: OCT. 2016	Approved: W.Z

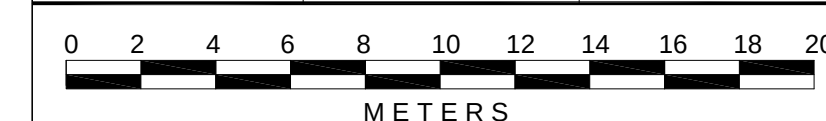


Drawing Number:

E-201

Rev.:	
-------	--

0


MATCH LINE SEE DWG. No. E-201

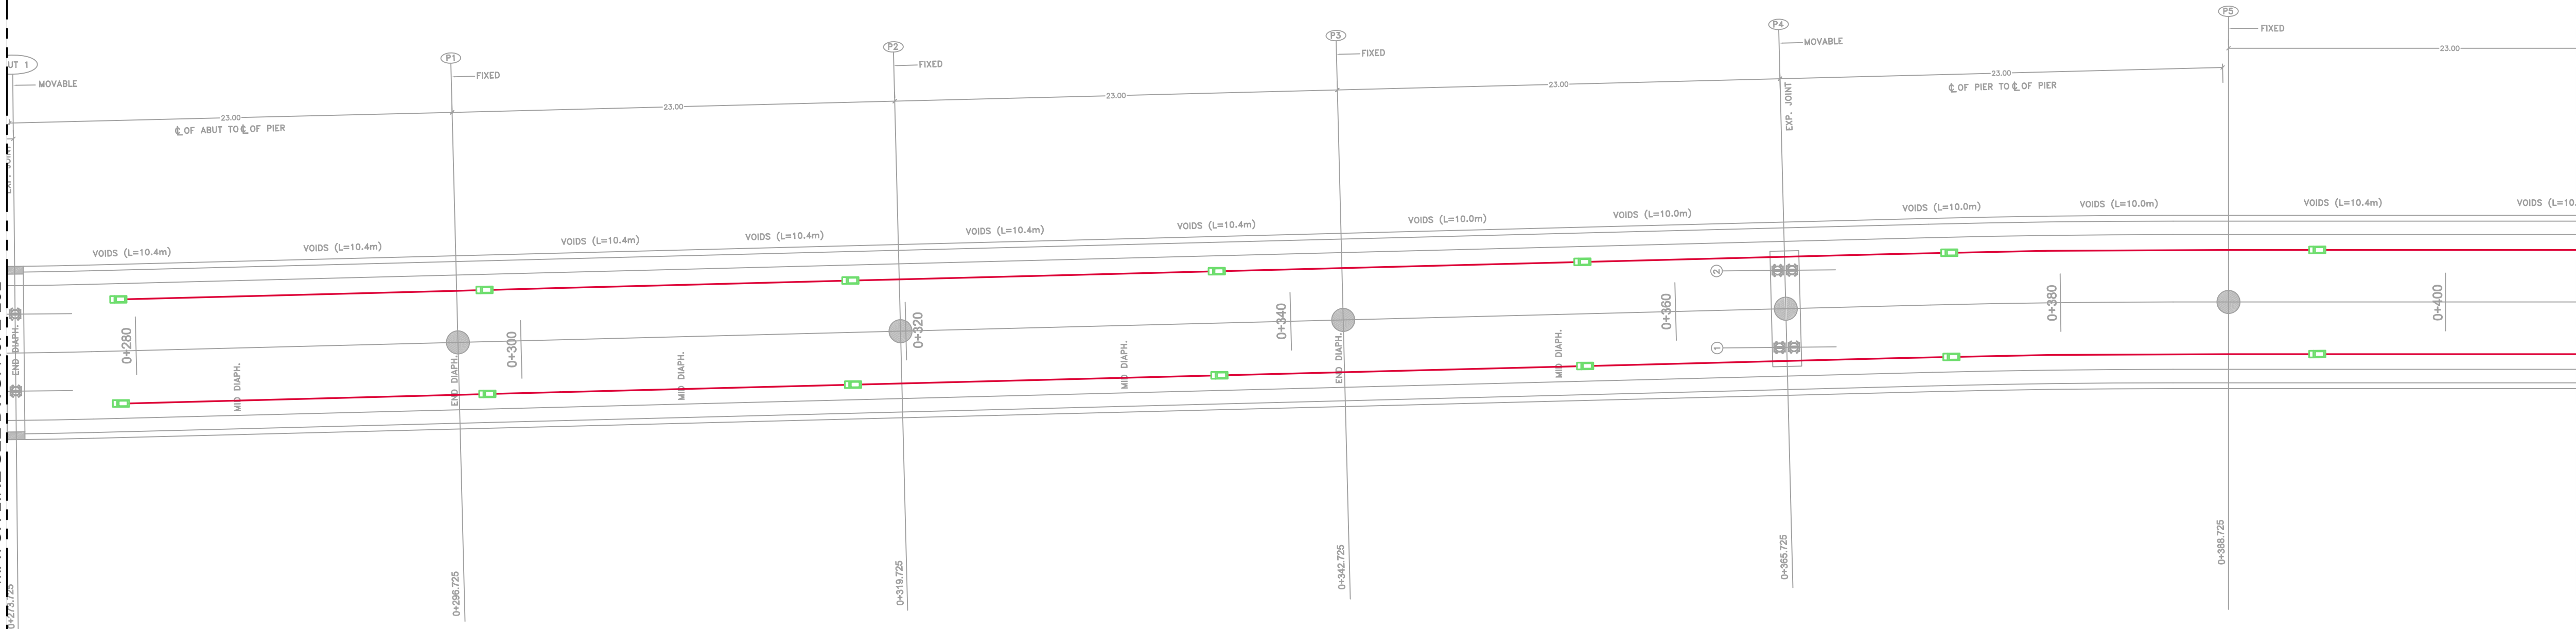


MATCH LINE SEE DWG. No. E-203

NOTES:-


KEY MAP:-

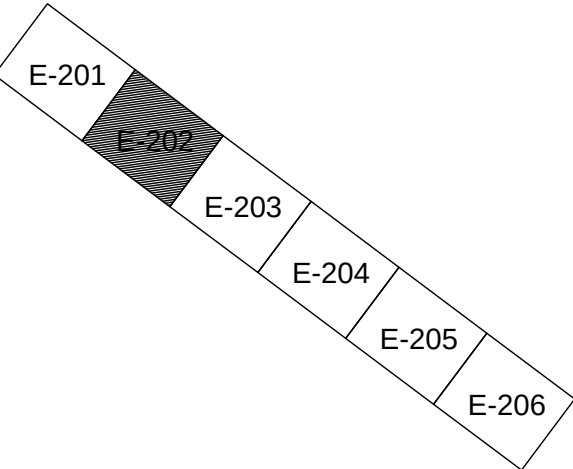

Purpose Of Issue	Rev.	Date	Approved

 Client:	 GREATER AMMAN MUNICIPALITY		
Project:	STRUCTURAL DESIGN SERVICES FOR AMMAN BRT		
Package:	PRESS TUNNEL		
Title:	BRIDGE AND TUNNEL LIGHTING SYSTEM LAYOUT SHEET (2 OF 6)		
Consultant:	 		
Design:	S.H.	Drawn by:	CAD
Scale:	1:200	Date:	OCT. 2016
Checked:	KH.A.	Approved:	W.Z.
			
Drawing Number:			Rev.:
E-202			0


MATCH LINE SEE DWG. No. E-202

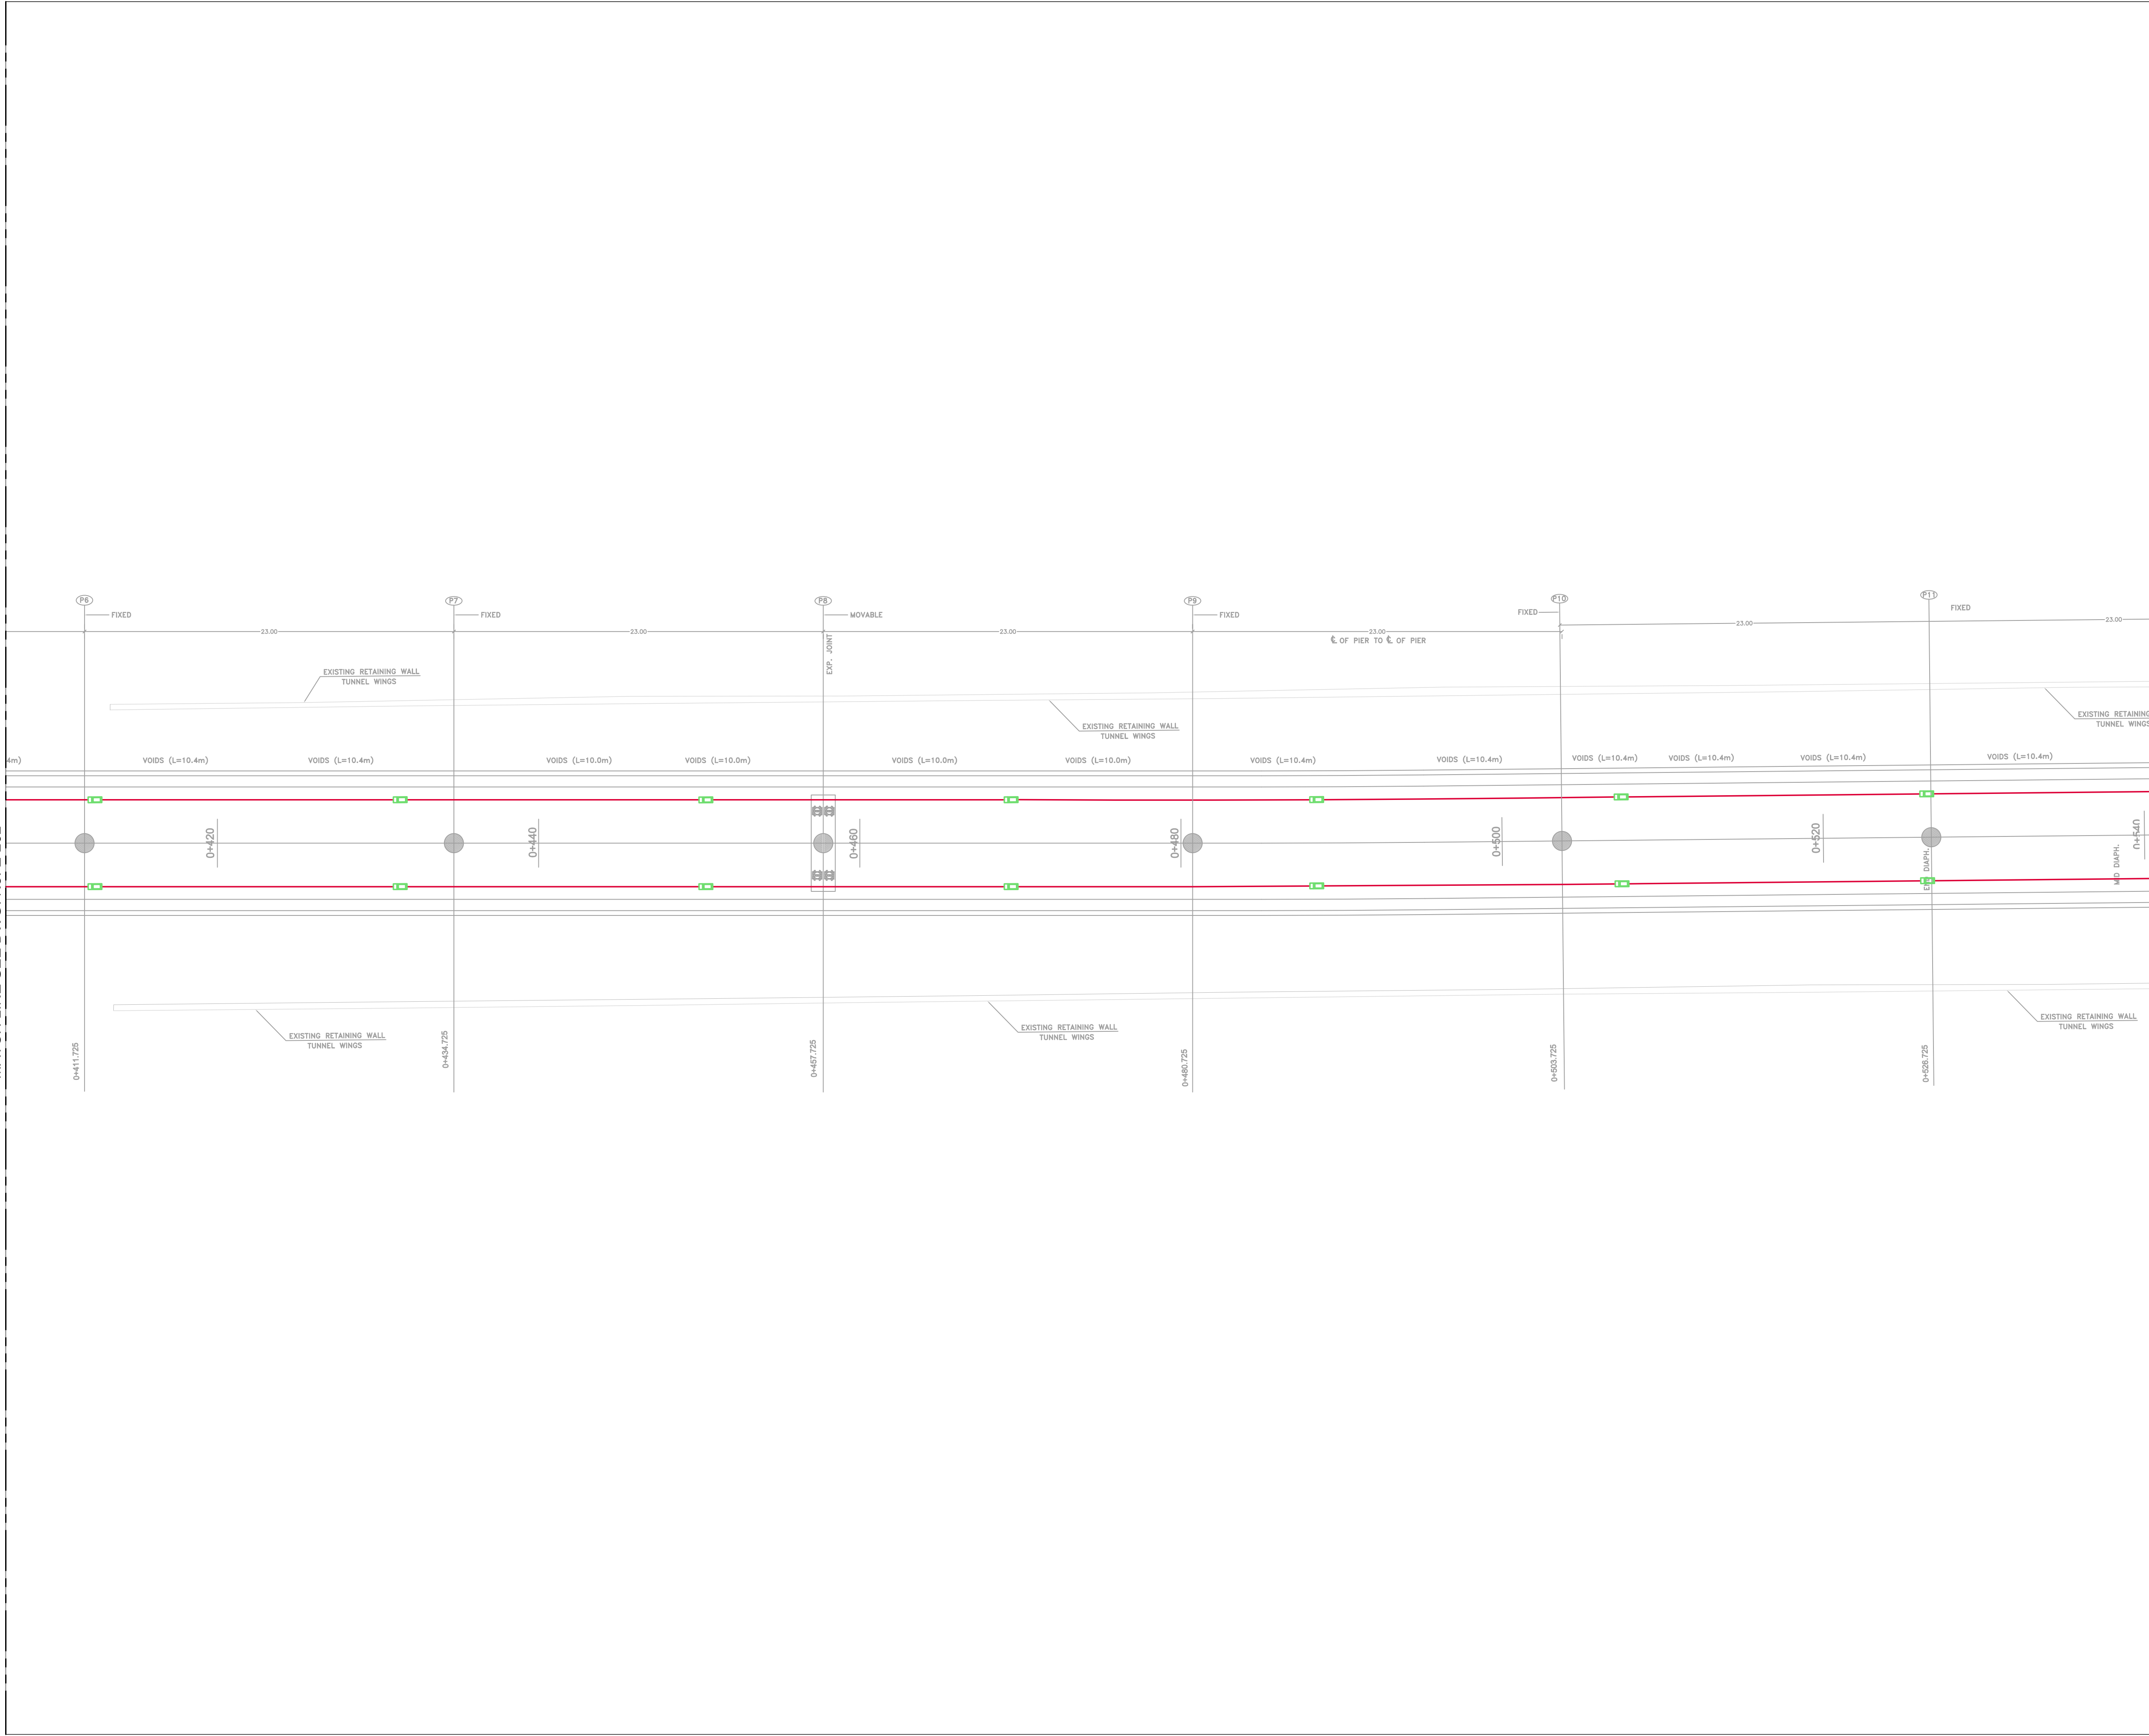

MATCH LINE SEE DWG. No. E-204

NOTES:-

KEY MAP:-

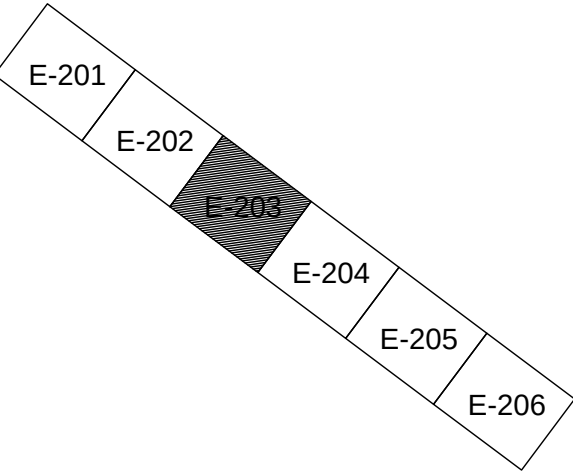

Purpose Of Issue	Rev.	Date	Approved

Client:

GREATER AMMAN MUNICIPALITY

Project:
STRUCTURAL DESIGN SERVICES FOR
AMMAN BRT


Package:
PRESS TUNNEL

Title:
BRIDGE AND TUNNEL
LIGHTING SYSTEM LAYOUT
SHEET (3 OF 6)

Consultant:




Design: S.H.	Drawn by: CAD	Checked: KH.A.
Scale: 1:200	Date: OCT. 2016	Approved: W.Z.

 
0 2 4 6 8 10 12 14 16 18 20
M E T E R S

Drawing Number: E-203	Rev.: 0
--------------------------	------------


MATCH LINE SEE DWG. No. E-203

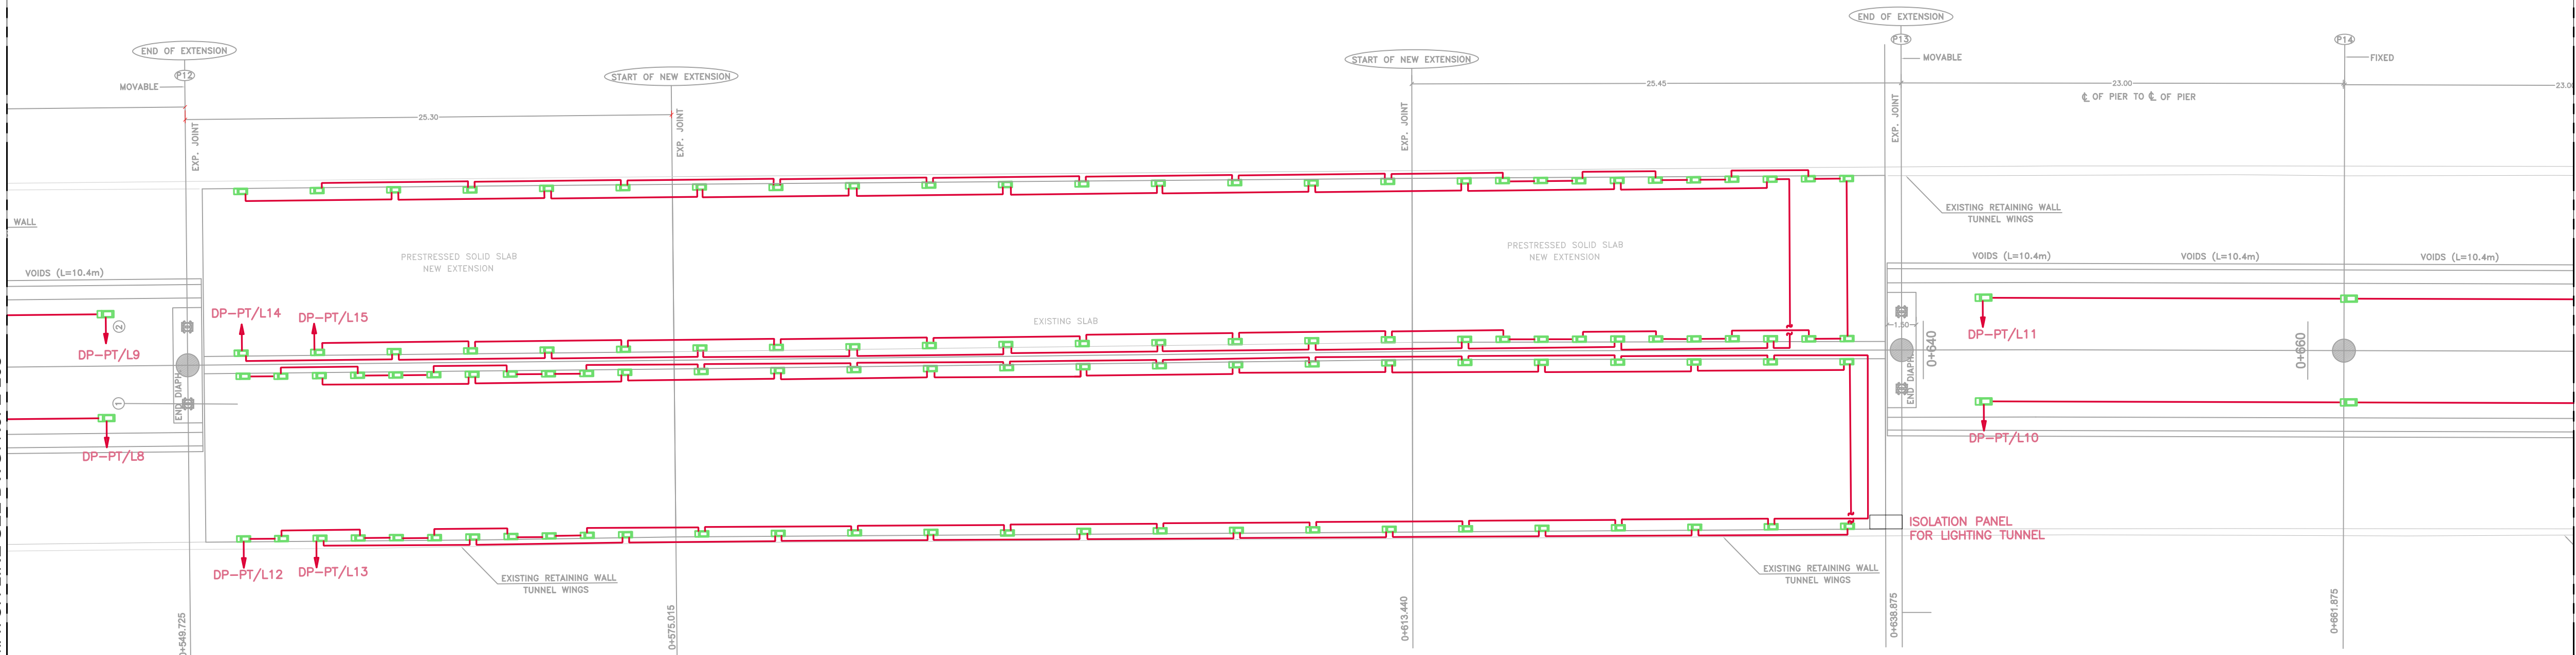

MATCH LINE SEE DWG. No. E-205

NOTES:-

KEY MAP:-

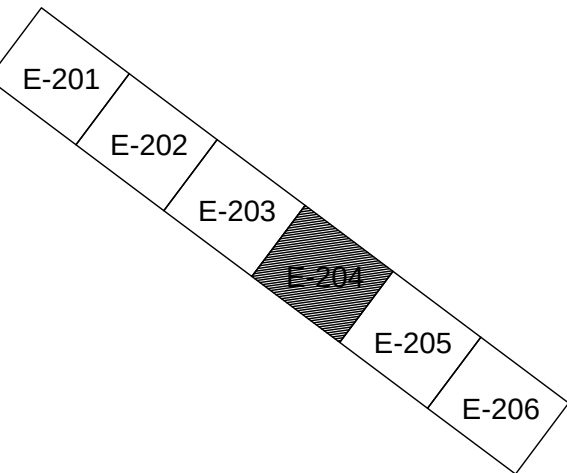

Purpose Of Issue	Rev.	Date	Approved

Client:



GREATER AMMAN MUNICIPALITY

Project:

STRUCTURAL DESIGN SERVICES FOR
AMMAN BRT

Package:

PRESS TUNNEL


Title:

BRIDGE AND TUNNEL
LIGHTING SYSTEM LAYOUT
SHEET (4 OF 6)

Consultant:




Design:	Drawn by:	Checked:
S.H.	CAD	KH.A.
Scale:	Date:	Approved:
1:200	OCT. 2016	W.Z.

 

Drawing Number:	Rev.:
E-204	0


MATCH LINE SEE DWG. No. E-204

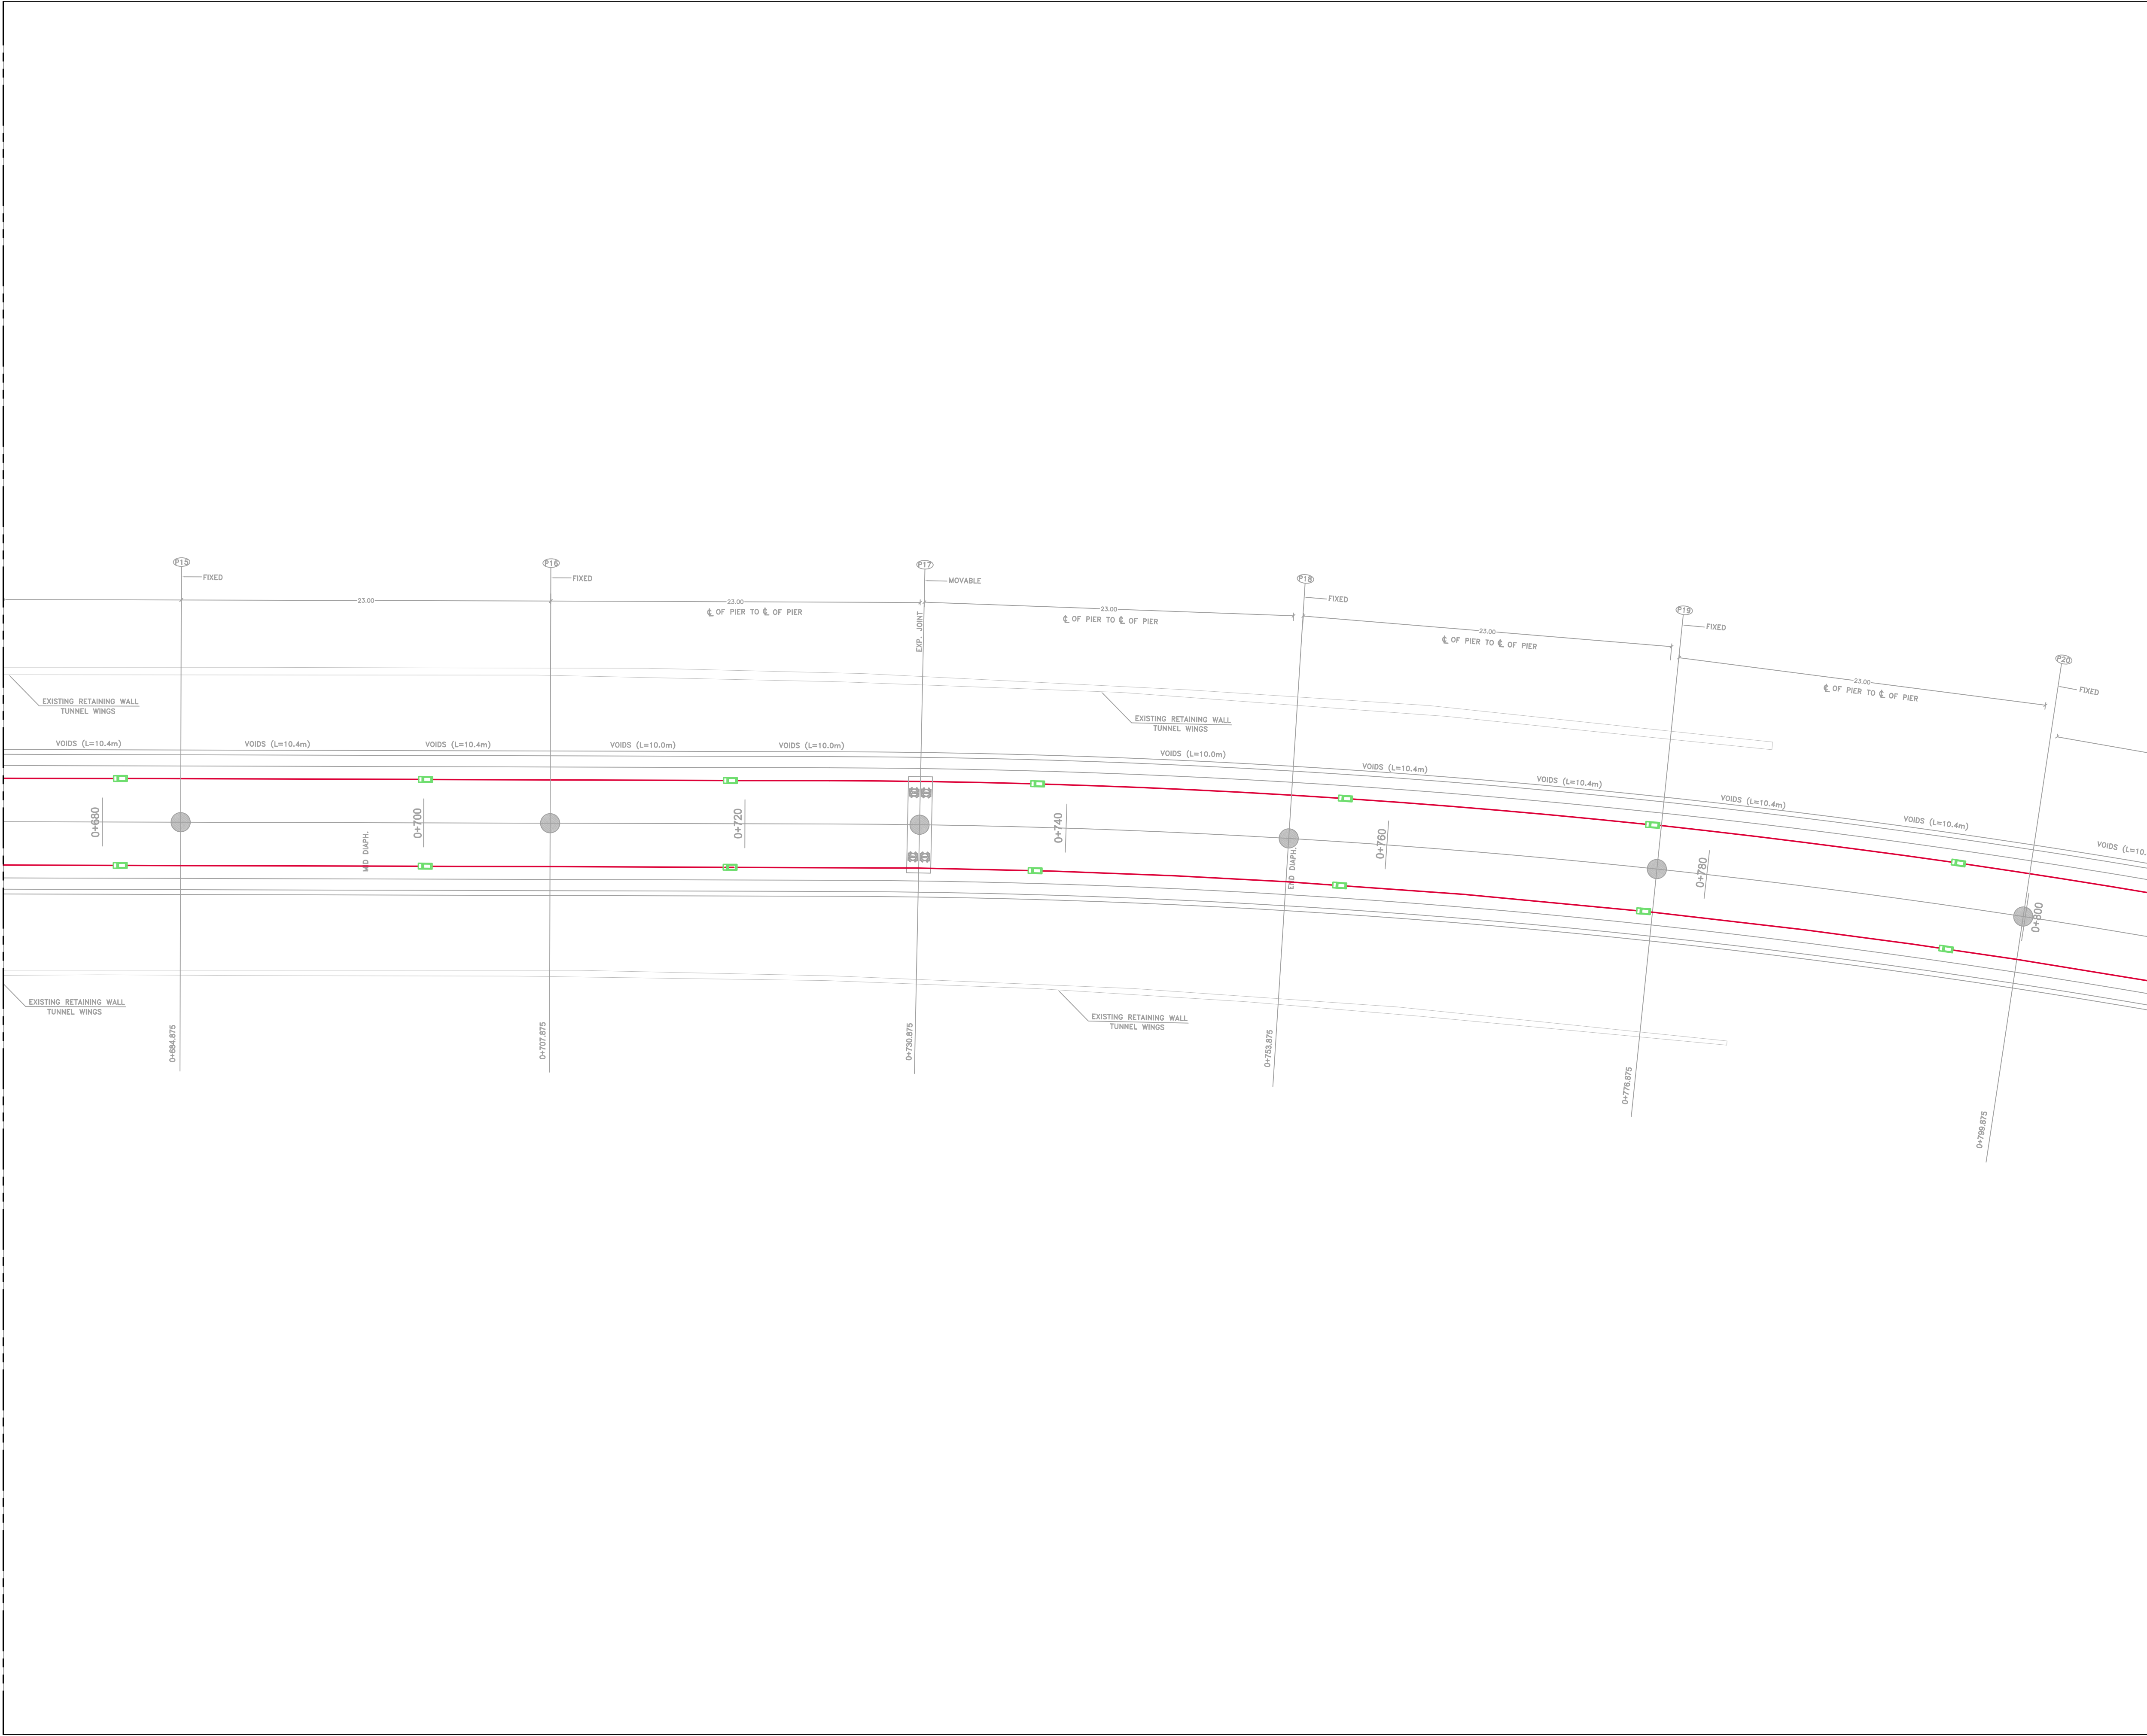

MATCH LINE SEE DWG. No. E-206

NOTES:-

KEY MAP:-

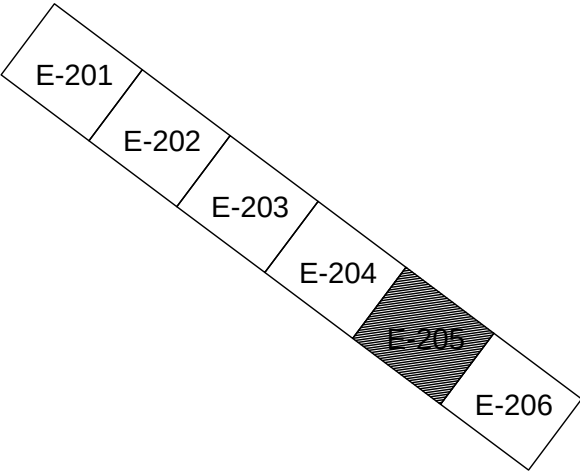

Purpose Of Issue	Rev.	Date	Approved
------------------	------	------	----------

Client:



أمانة
عمان
الكبرى

GREATER AMMAN MUNICIPALITY

Project:

STRUCTURAL DESIGN SERVICES FOR
AMMAN BRT

Package:

PRESS TUNNEL

Title:


BRIDGE AND TUNNEL
LIGHTING SYSTEM LAYOUT
SHEET (5 OF 6)

Consultant:




Design:	S.H.	Drawn by:	CAD	Checked:	KH.A.
---------	------	-----------	-----	----------	-------


Scale:	1:200	Date:	OCT. 2016	Approved:	W.Z
--------	-------	-------	-----------	-----------	-----

 

Drawing Number:	E-205	Rev.:	0
-----------------	-------	-------	---

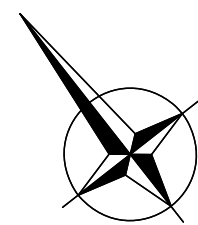

← TO JORDAN UNIVERSITY

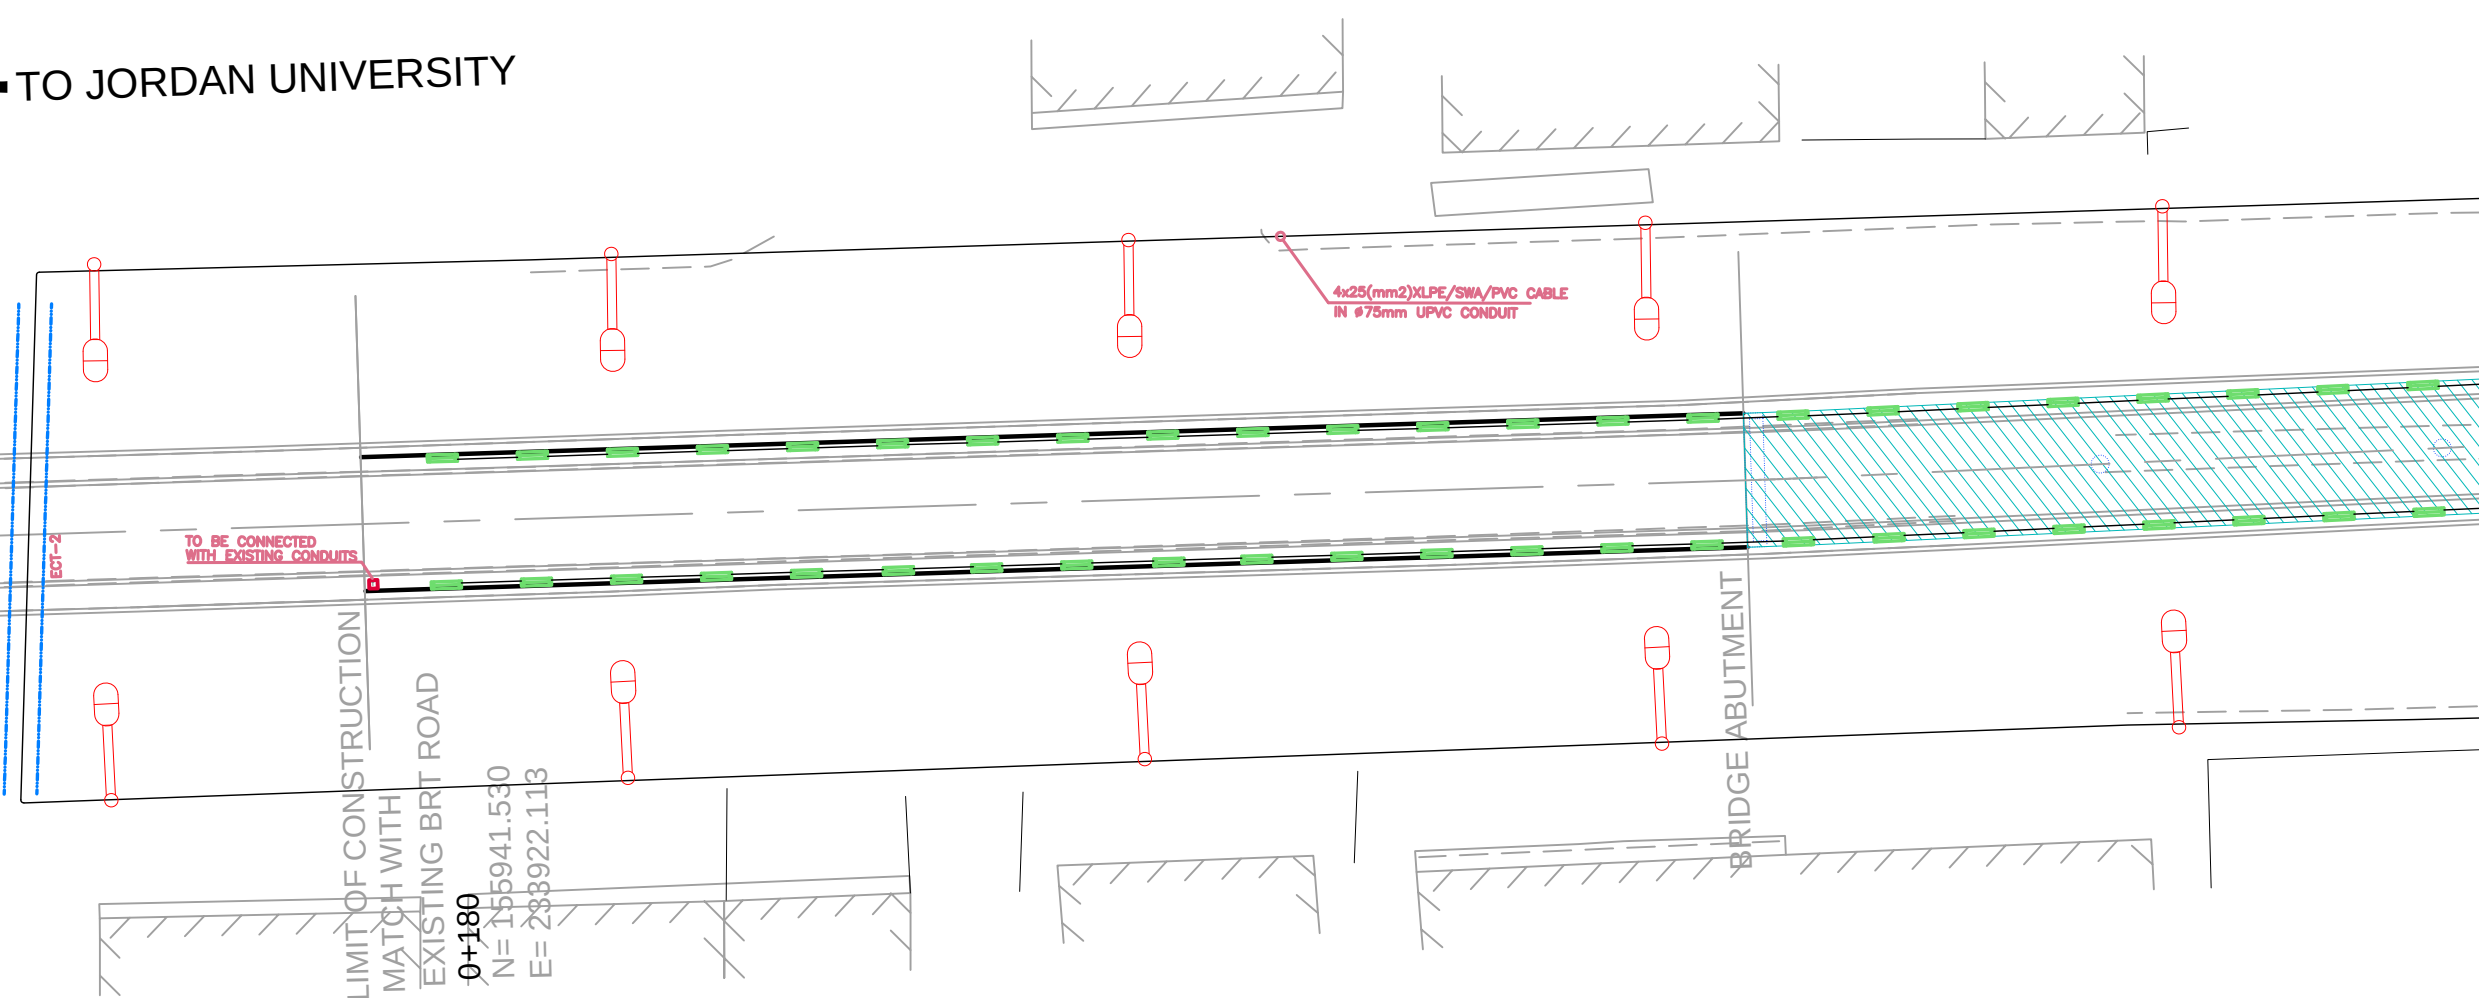

MATCH LINE SEE DWG. No. E-302

NOTES:-

Purpose Of Issue	Rev.	Date	Approved
------------------	------	------	----------

Client:



GREATER AMMAN MUNICIPALITY

Project:

STRUCTURAL DESIGN SERVICES FOR AMMAN BRT

Package:

PRESS TUNNEL


Title:

STREET LIGHTING LAYOUT
SHEET 1 OF 4


Consultant:



Design:	Drawn by:	Checked:
S.H	CAD	KH.A
Scale:	Date:	Approved:
1:500	NOV. 2016	W.Z.

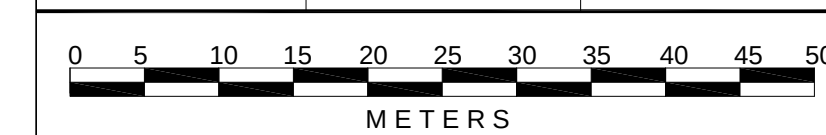

Drawing Number:	Rev.:
E-301	0

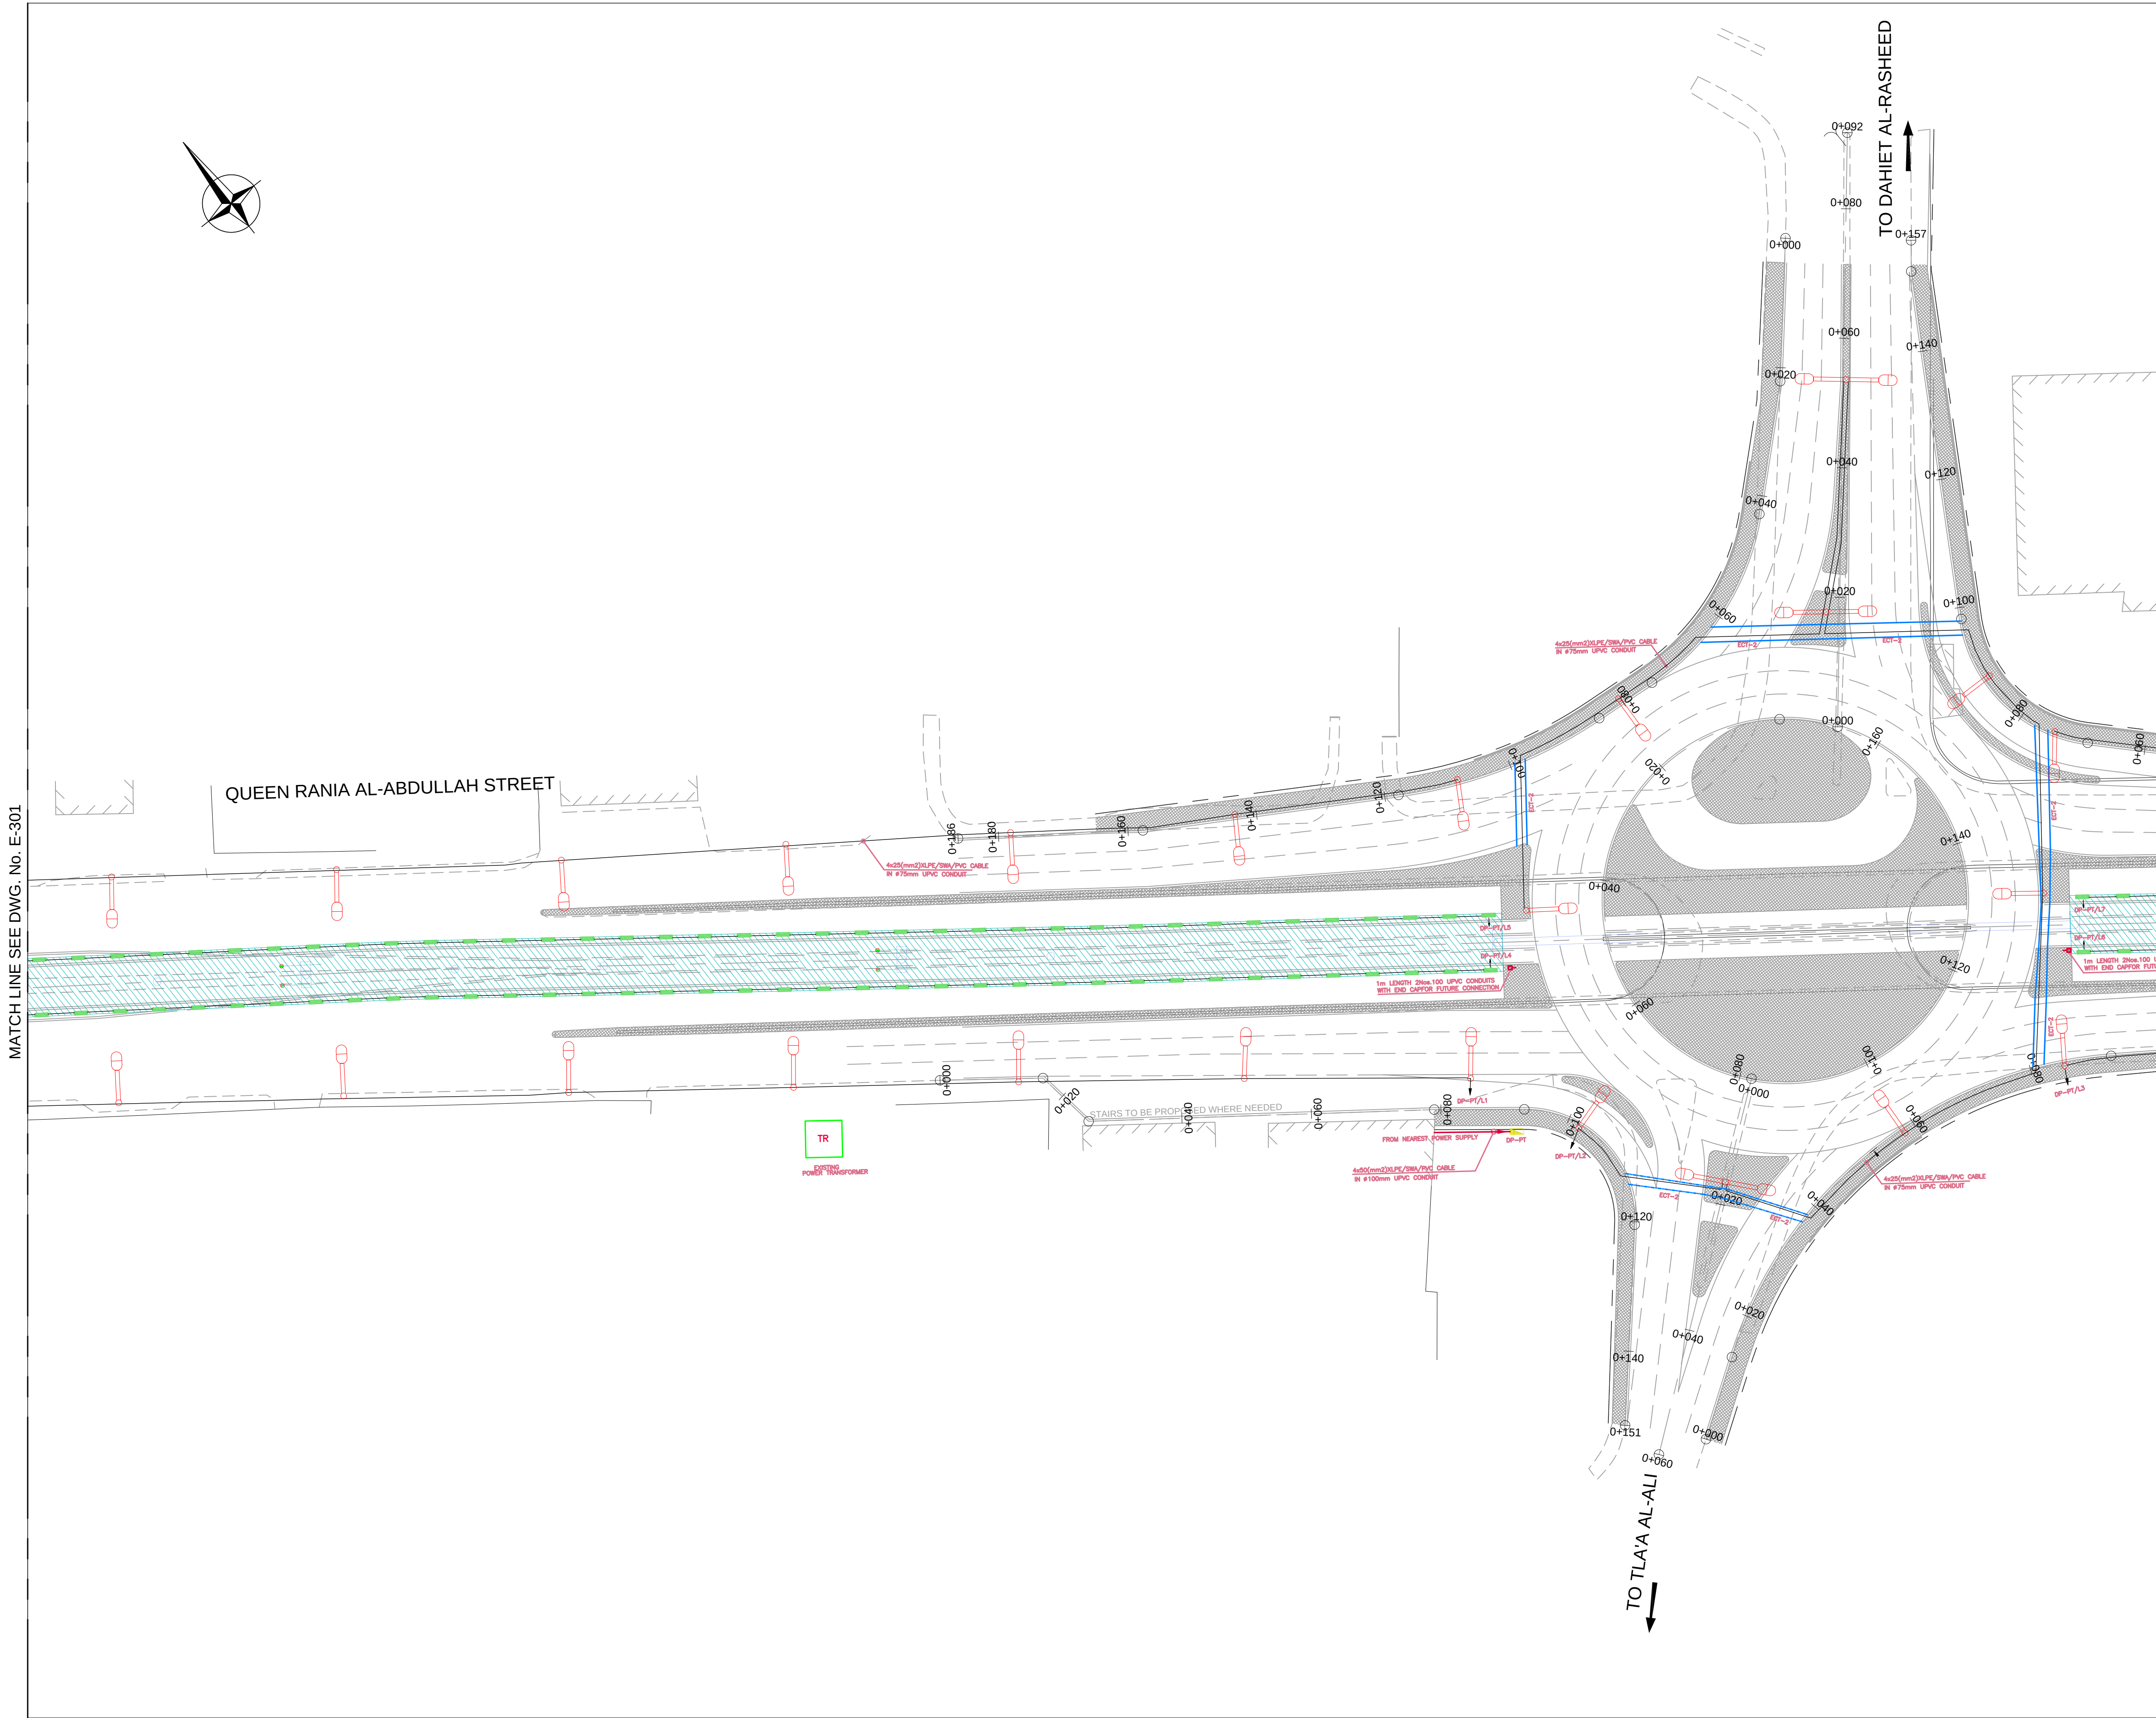

NOTES:-

Purpose Of Issue	Rev.	Date	Approved

Client:



أمانة
عمان
الكبرى

GREATER AMMAN MUNICIPALITY

Project:

STRUCTURAL DESIGN SERVICES FOR
AMMAN BRT

Package:

PRESS TUNNEL


Title:

STREET LIGHTING LAYOUT
SHEET 2 OF 4


Consultant:



Design: S.H	Drawn by: CAD	Checked: KH.A
Scale: 1:500	Date: NOV. 2016	Approved: W.Z.

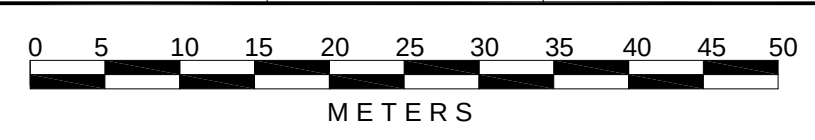

Drawing Number:	Rev.:
E-302	0

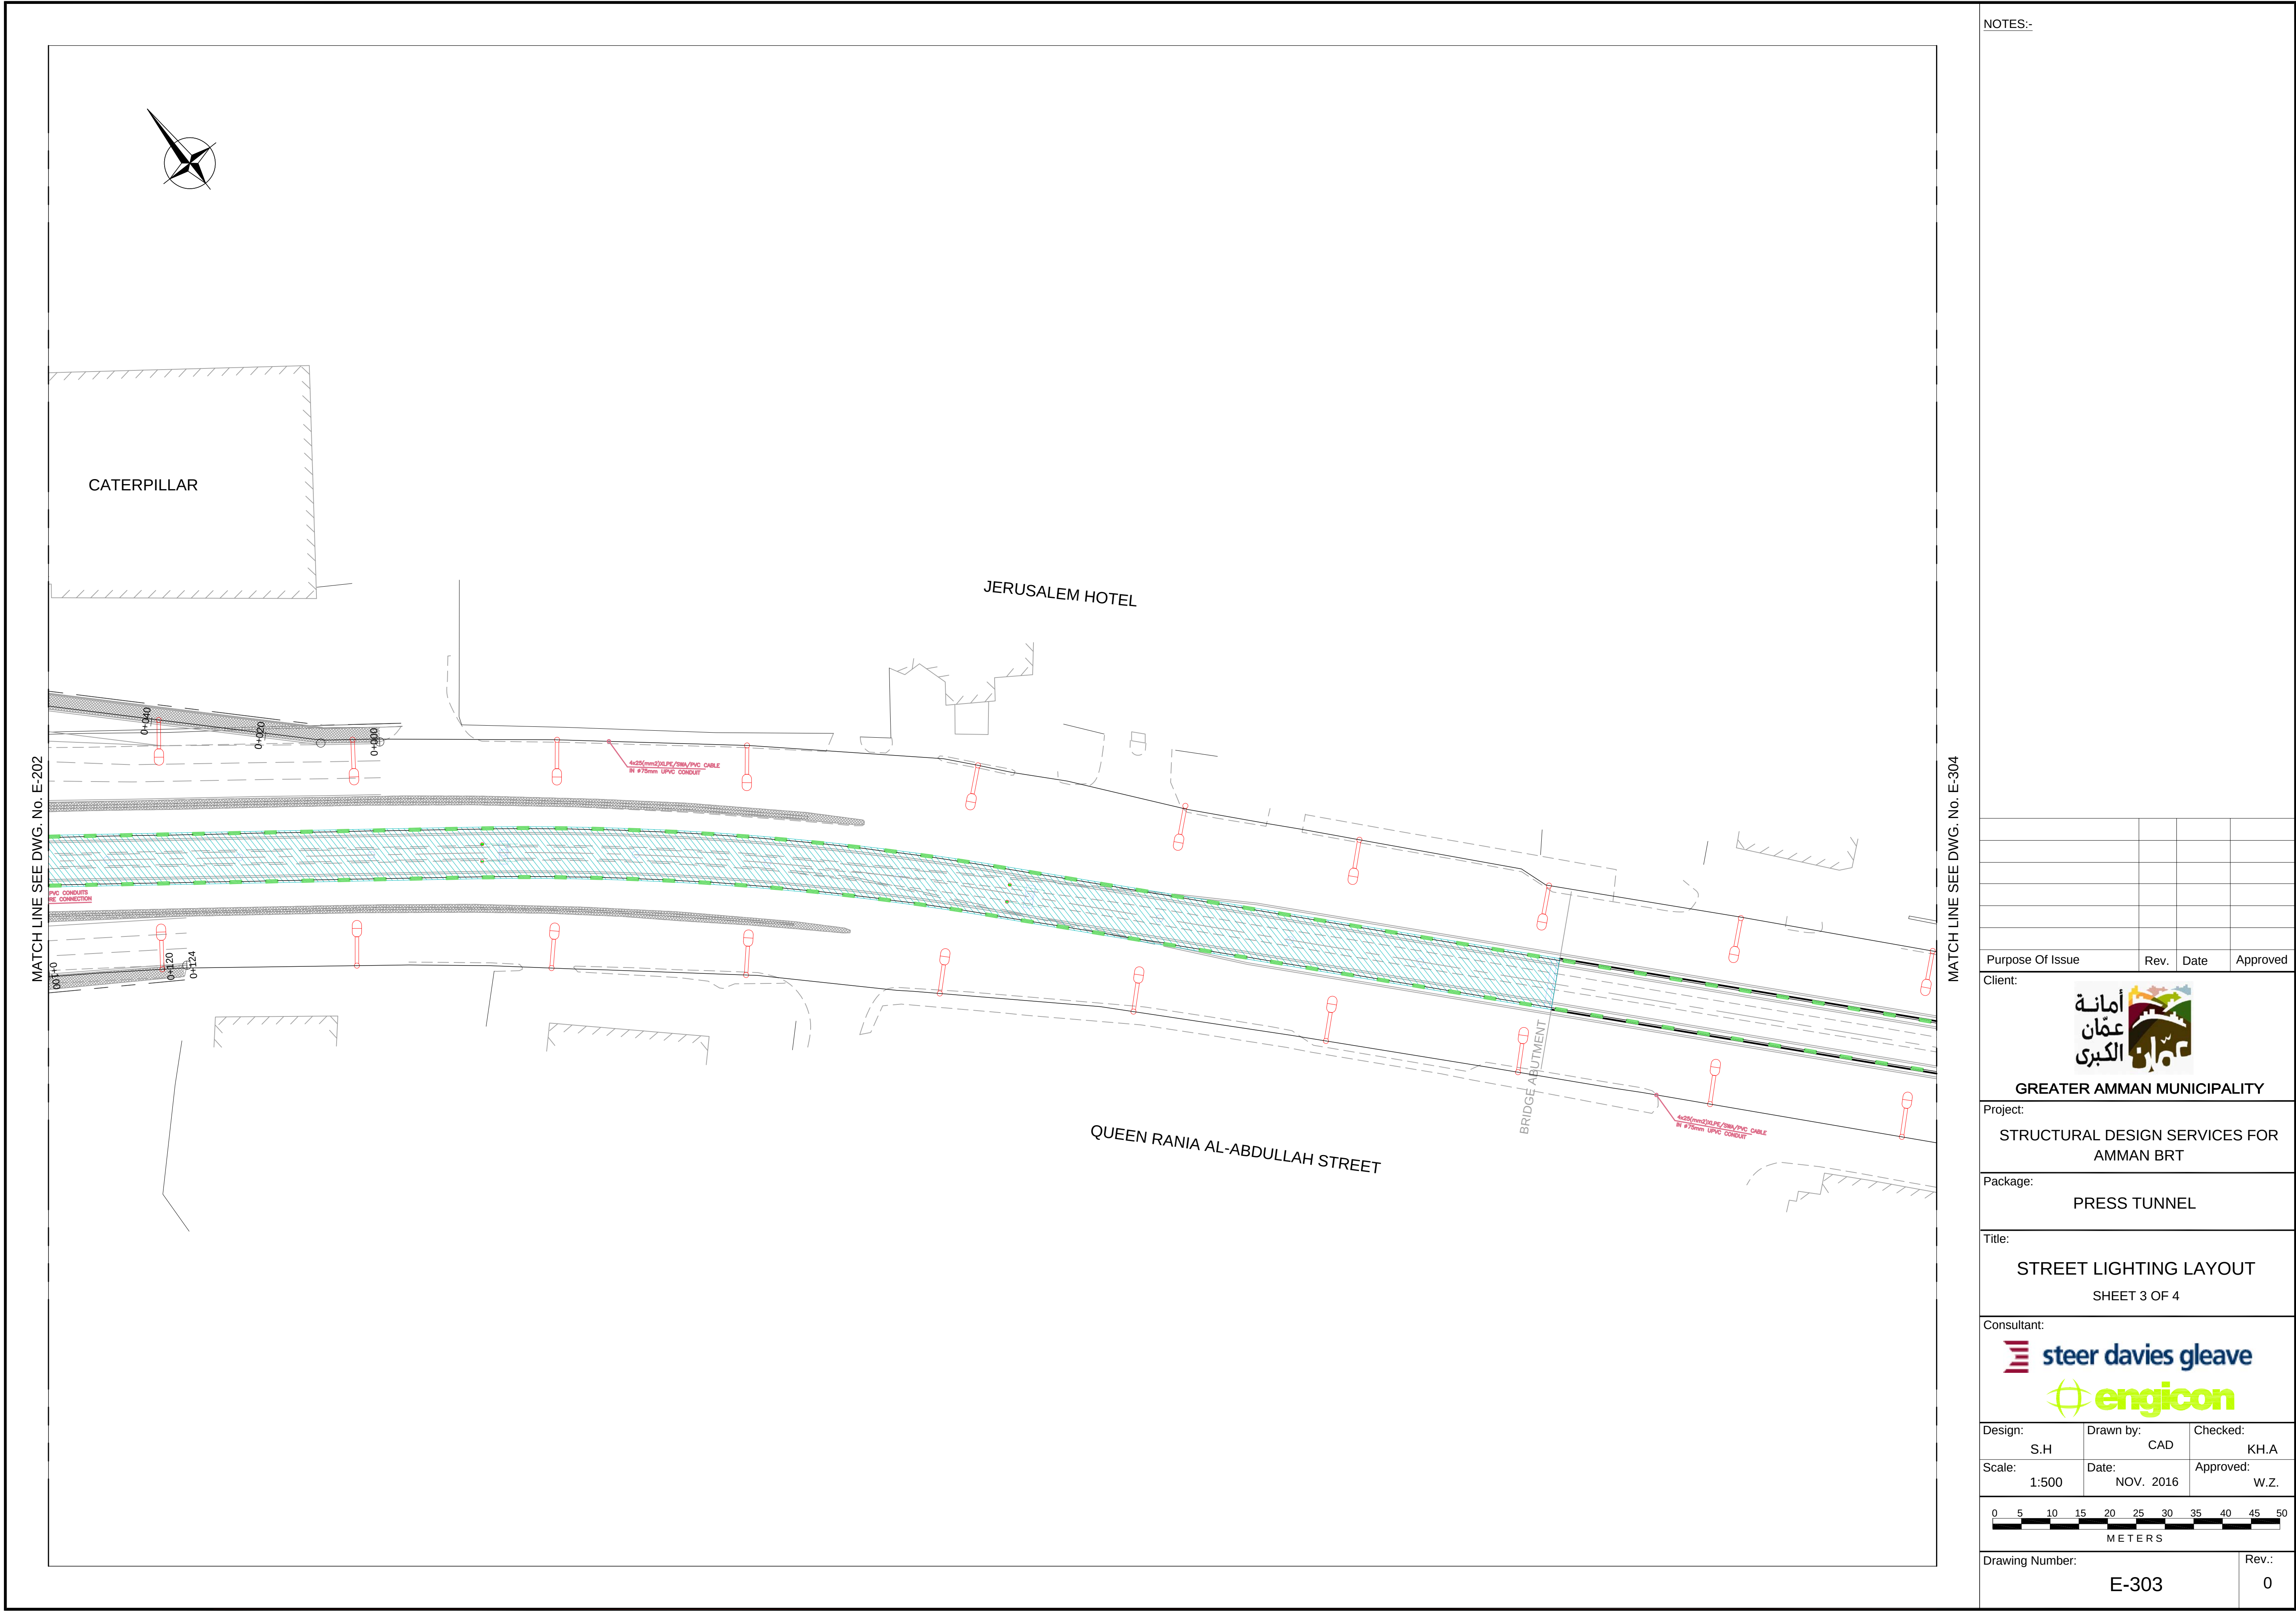

NOTES:-

Purpose Of Issue	Rev.	Date	Approved
------------------	------	------	----------

Client:



GREATER AMMAN MUNICIPALITY

Project:

STRUCTURAL DESIGN SERVICES FOR
AMMAN BRT

Package:

PRESS TUNNEL


Title:

STREET LIGHTING LAYOUT
SHEET 3 OF 4

Consultant:




Design:	Drawn by:	Checked:
S.H	CAD	KH.A
Scale:	Date:	Approved:
1:500	NOV. 2016	W.Z.

 

Drawing Number:	Rev.:
E-303	0

MATCH LINE SEE DWG. No. E-303

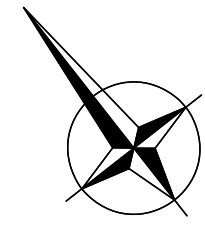

NOTES:-

Purpose Of Issue	Rev.	Date	Approved
------------------	------	------	----------

Client:



GREATER AMMAN MUNICIPALITY

Project:

STRUCTURAL DESIGN SERVICES FOR
AMMAN BRT

Package:

PRESS TUNNEL


Title:

STREET LIGHTING LAYOUT
SHEET 4 OF 4

Consultant:



Design: S.H	Drawn by: CAD	Checked: KH.A
Scale: 1:500	Date: NOV. 2016	Approved: W.Z.

 

Drawing Number: E-304	Rev.: 0
--------------------------	------------



Purpose Of Issue	Rev.	Date	Approved
------------------	------	------	----------



GREATER AMMAN MUNICIPALITY

Project: **STRUCTURAL DESIGN SERVICES FOR
AMMAN BRT**

Package: PRESS TUNNEL

Title:	ELECTRICAL DETAILS-1
--------	----------------------

Consultant:



 **steer davis gleave**

 **engicon**


Design: S.H	Drawn by: CAD	Checked: KH.A
Scale: N.T.S.	Date: NOV. 2016	Approved: W.Z.




Drawing Number:	Rev.:
E-801	0

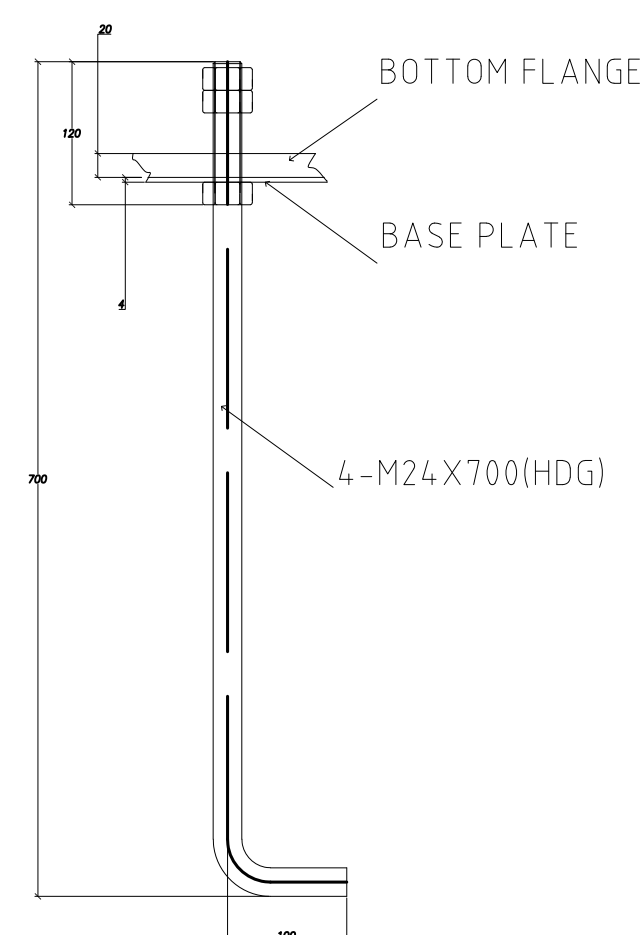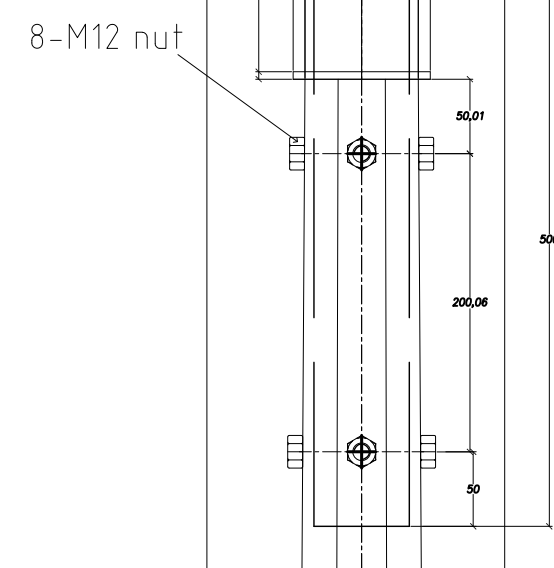

hook
(50mm long×50mm high)

 

 1. All dimensions are in millimeters unless otherwise shown
2. Pole comply BC 5649/en40, octagonal type (wind speed 250km/Hrs)
3. Thickness of galvanization (hot dip galvanized) is more than 85um
4. The material for shaft and arm is steel ST52-3 (Q345C), for base plate is steel ST44-2 (Q235B)



hook
/ (50mm long×50mm high)

Purpose Of Issue	Rev.	Date	Approved

أمانة
عمّان
الكبرى

 
STRUCTURAL DESIGN SERVICES FOR
AMMAN BRT

PRESS TUNNEL

ELECTRICAL DETAILS-2




W.Z




E-802


0

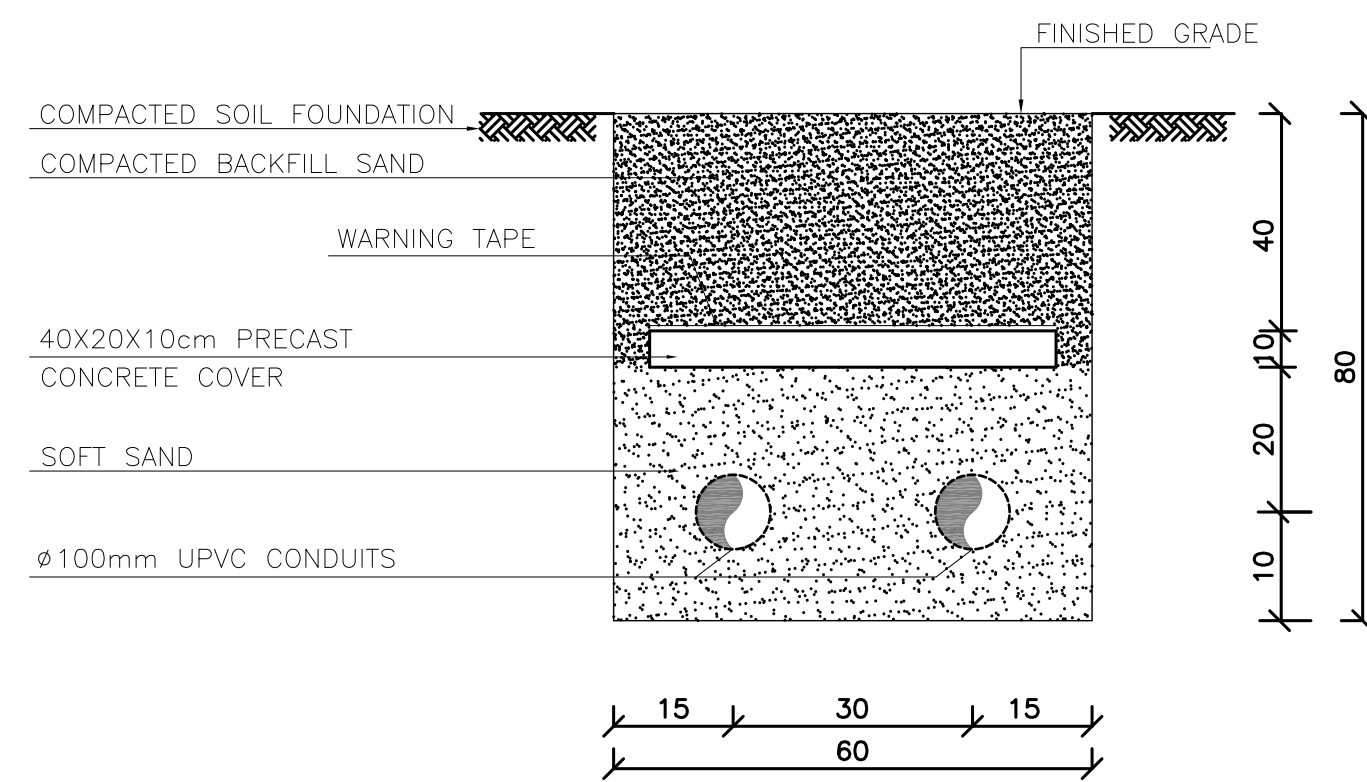


ELECTRICAL POWER TRENCH
N.T.S

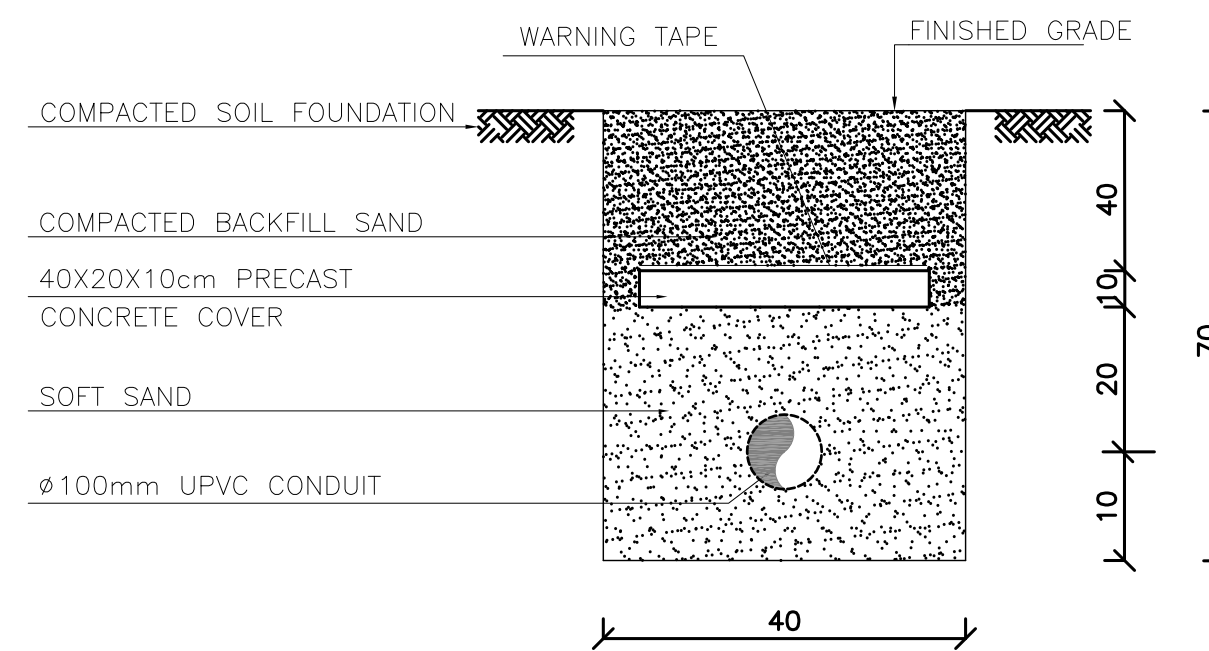


ELECTRICAL POWER TRENCH
N.T.S

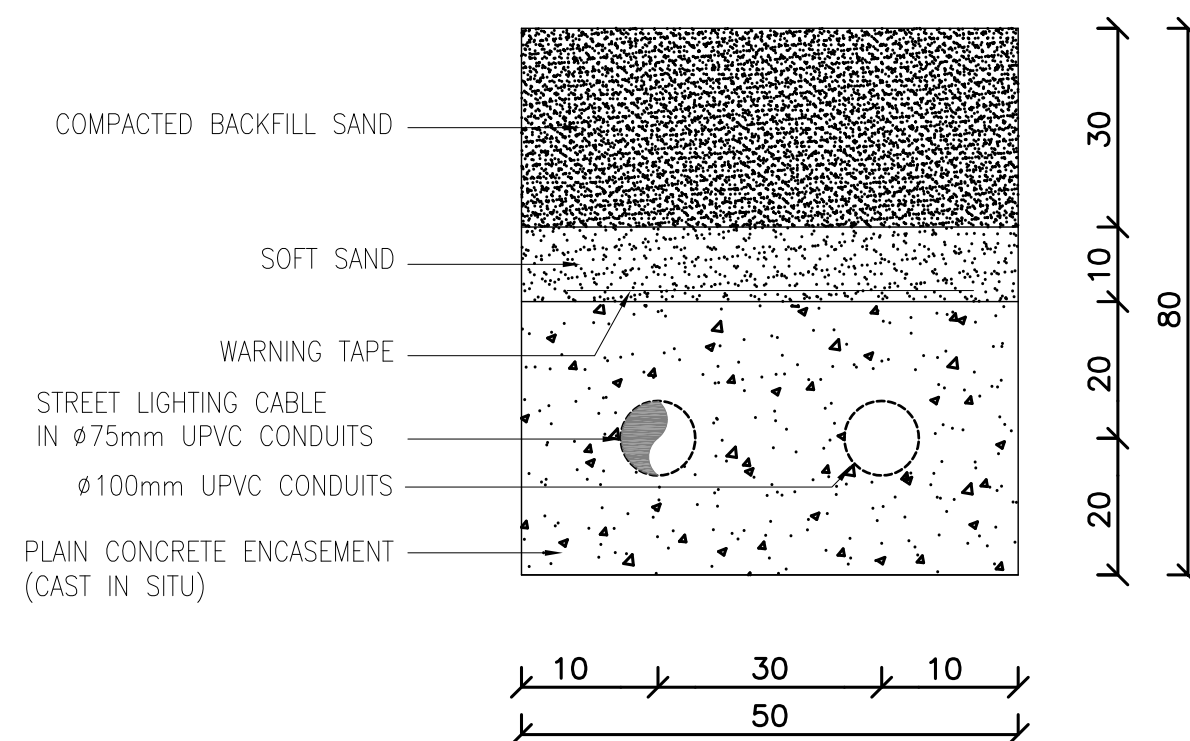

ELECTRICAL CONCRETE TRENCH
(ECT-2)
N.T.S

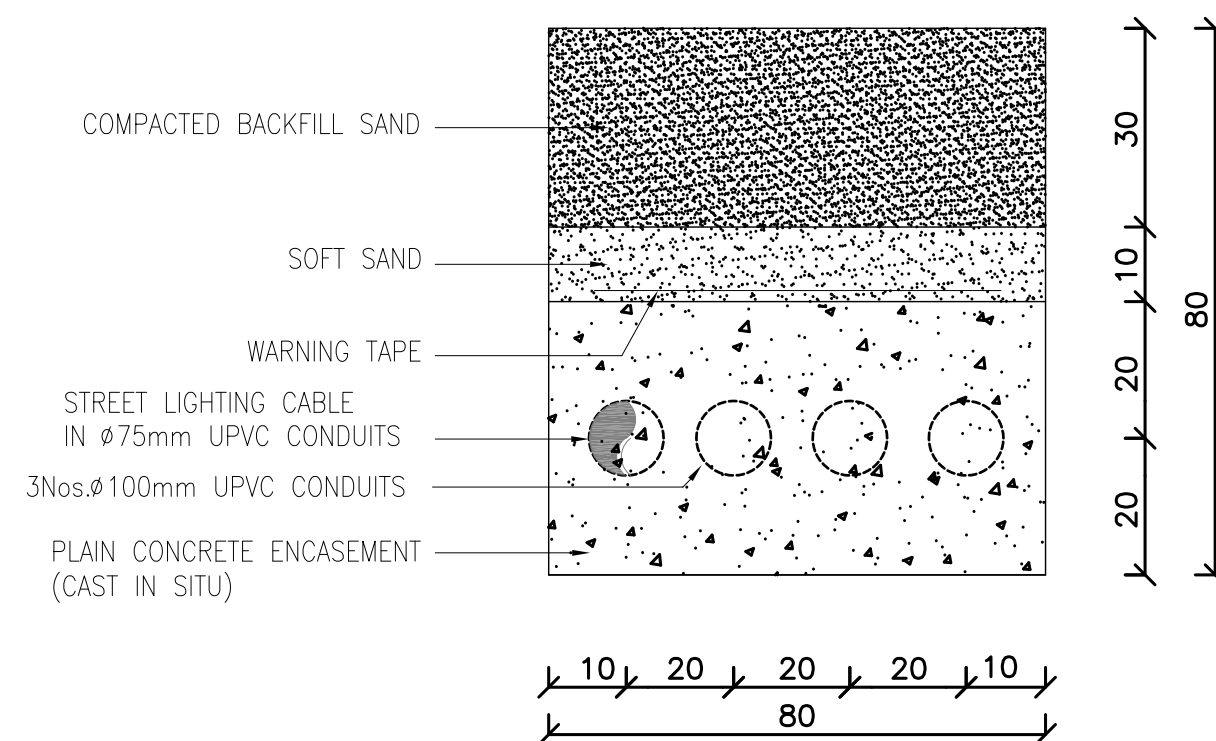

ELECTRICAL CONCRETE TRENCH
(ECT-2)
N.T.S

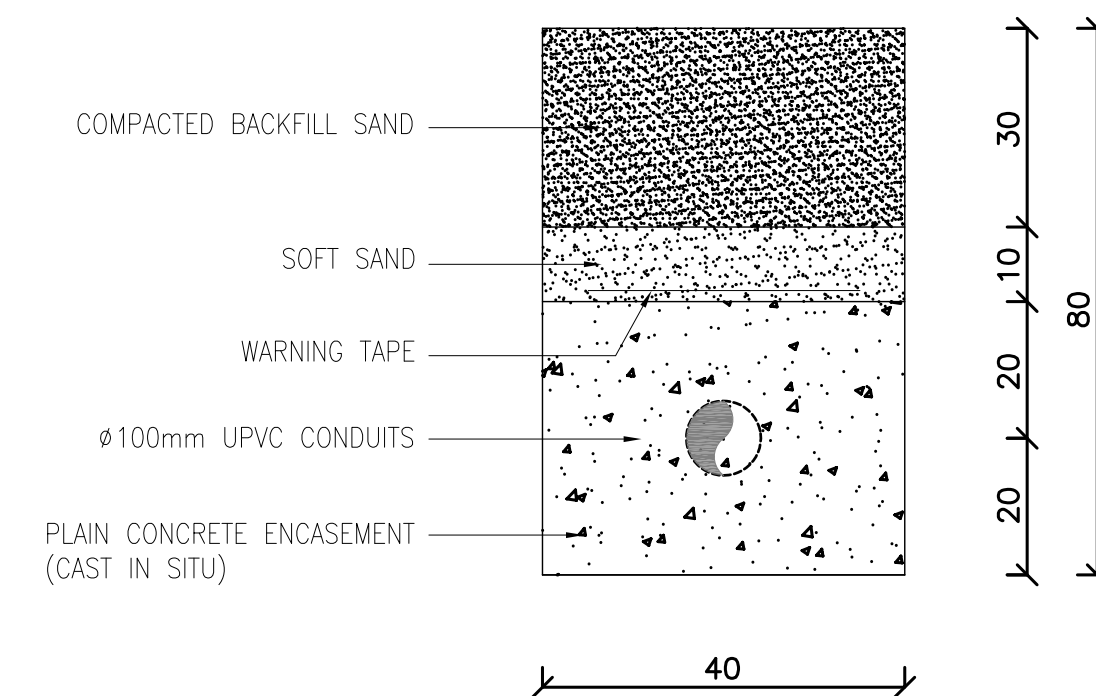

ELECTRICAL CONCRETE TRENCH
(ECT-3)
N.T.S

NOTES:-

Purpose Of Issue	Rev.	Date	Approved
------------------	------	------	----------

Client:



GREATER AMMAN MUNICIPALITY

Project:

STRUCTURAL DESIGN SERVICES FOR
AMMAN BRT

Package:

PRESS TUNNEL

Title:

ELECTRICAL DETAILS-3

Consultant:



Design:	Drawn by:	Checked:
---------	-----------	----------

S.H	CAD	KH.A
-----	-----	------

Scale:	Date:	Approved:
--------	-------	-----------

N.T.S.	NOV. 2016	W.Z.
--------	-----------	------




Drawing Number:

E-803

Rev.:

0

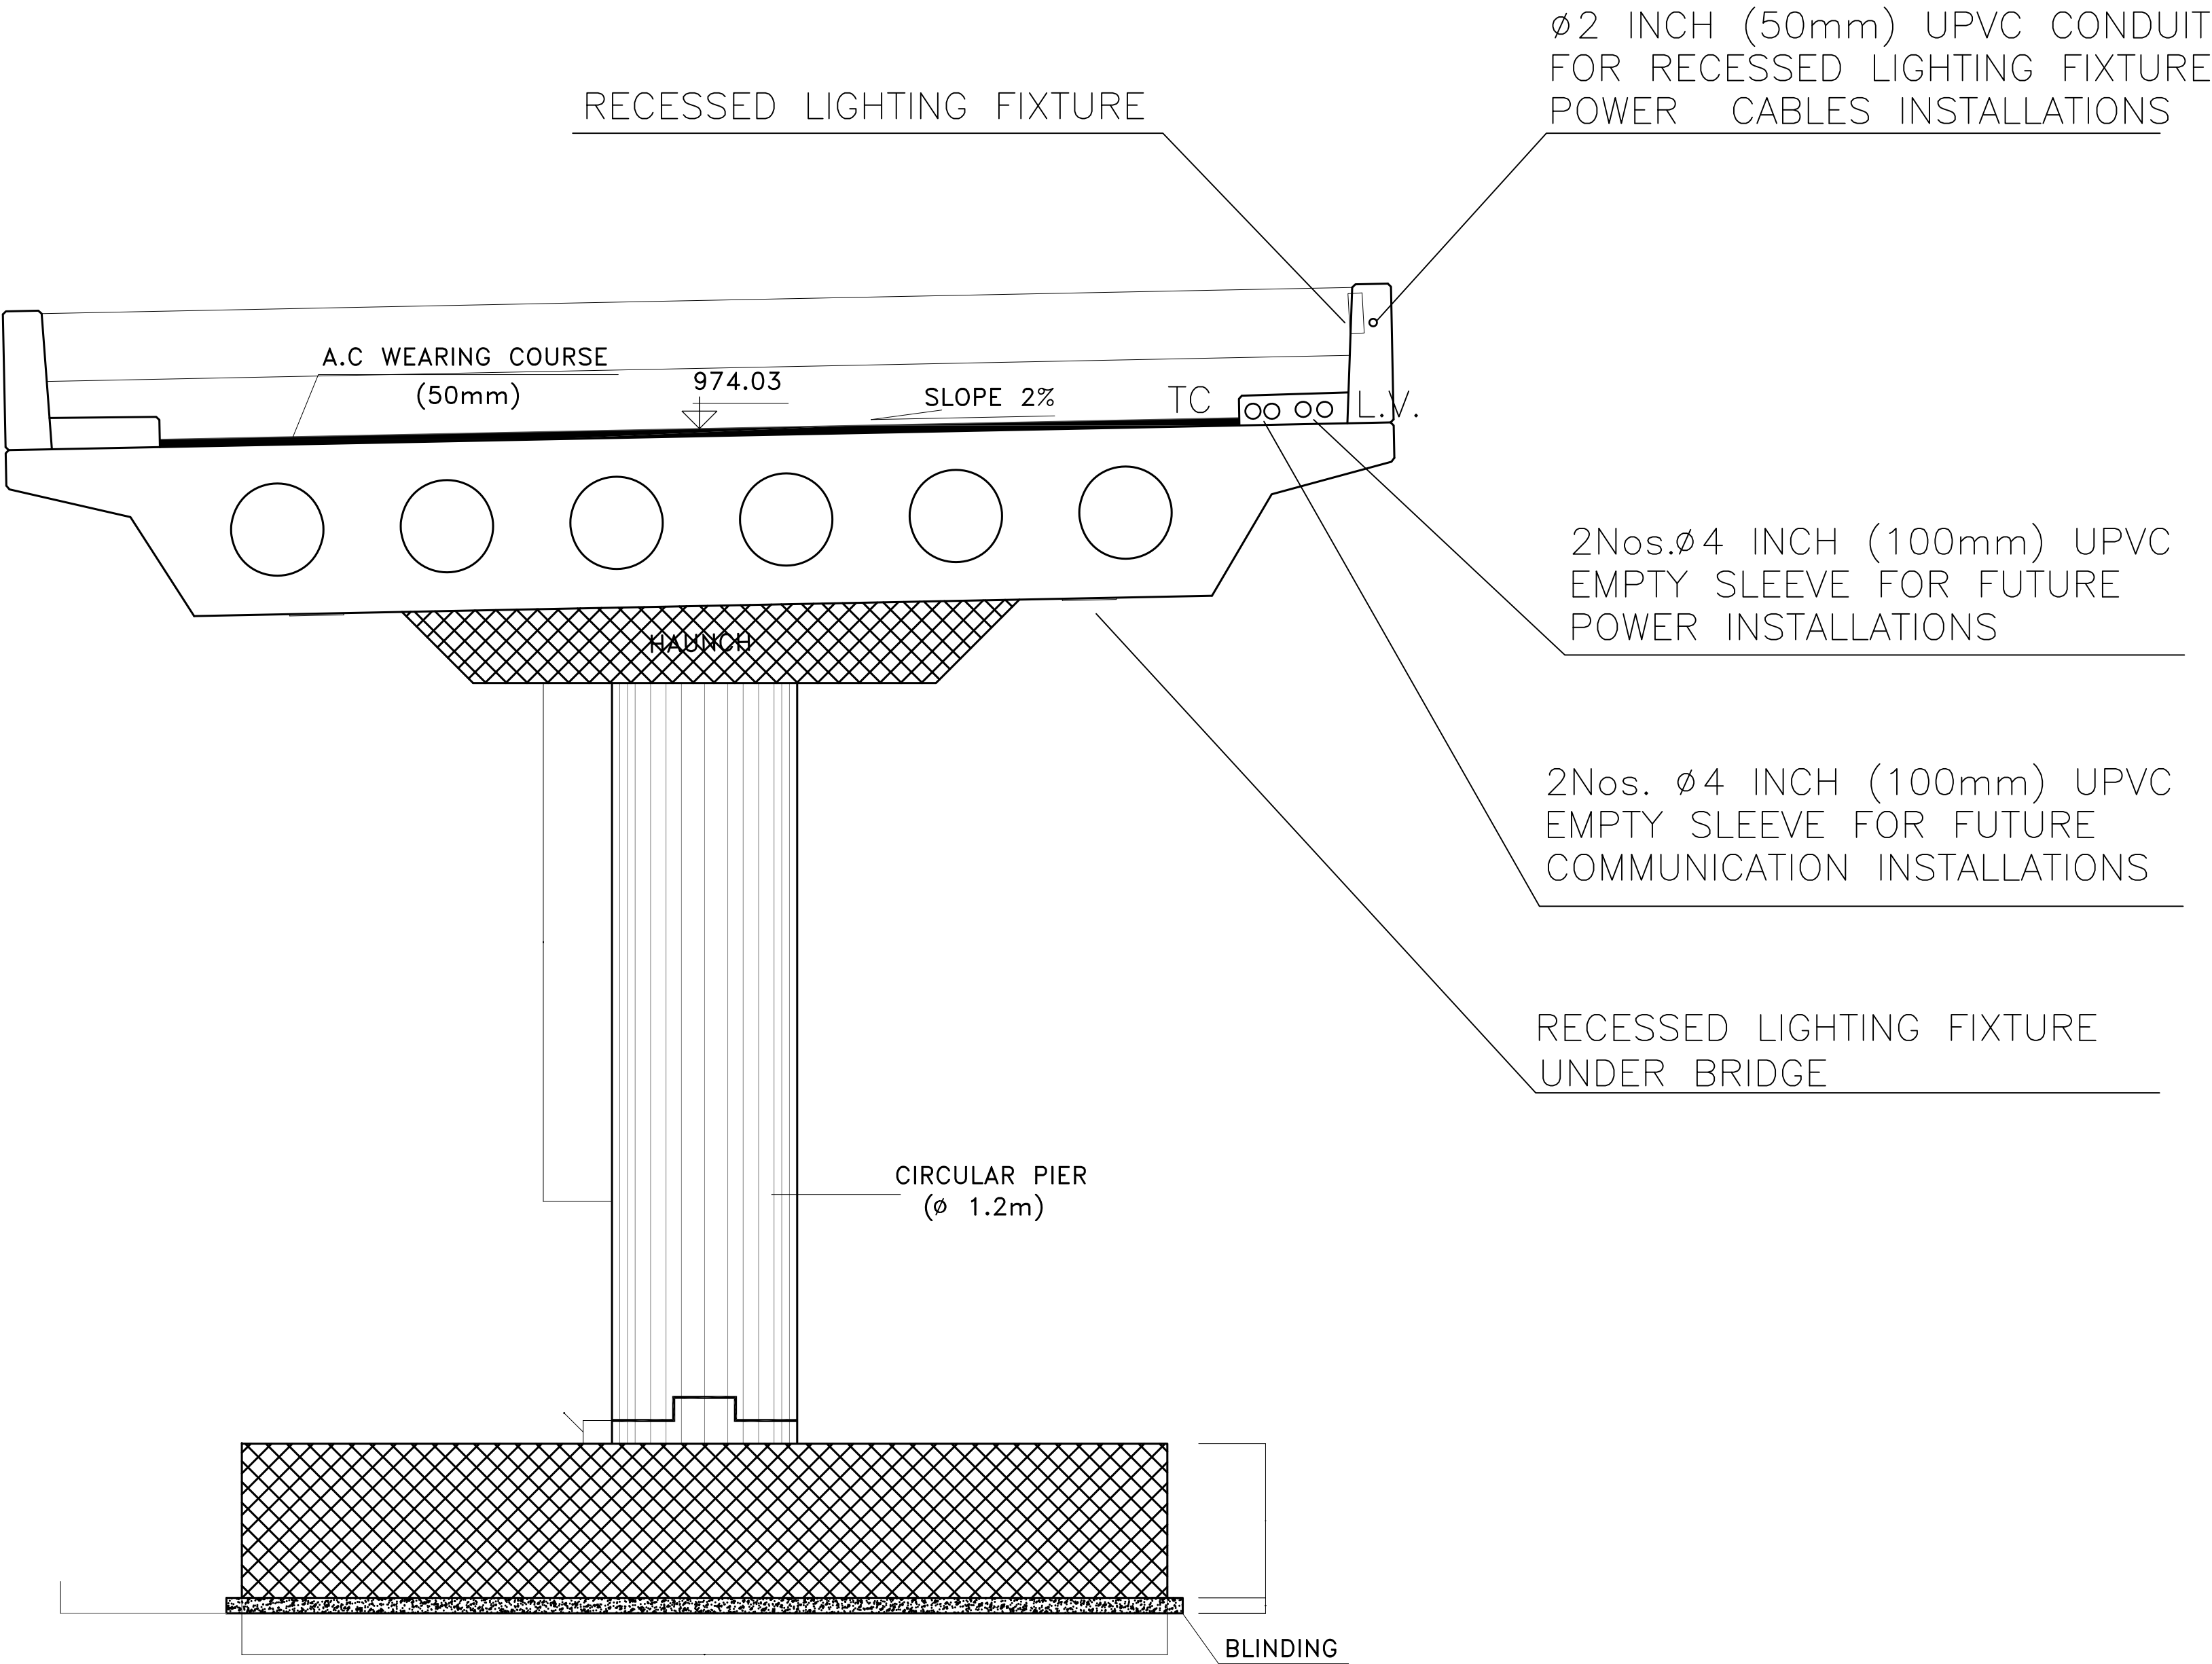

NOTES:-

Purpose Of Issue	Rev.	Date	Approved
------------------	------	------	----------

Client:


GREATER AMMAN MUNICIPALITY

Project:

STRUCTURAL DESIGN SERVICES FOR
AMMAN BRT

Package:

PRESS TUNNEL

Title:

ELECTRICAL DETAILS-5

Consultant:




Design:	Drawn by:	Checked:
S.H	CAD	KH.A
Scale:	Date:	Approved:
N.T.S.	NOV. 2016	W.Z.


M E T E R S

Drawing Number:	Rev.:
E-805	0